

 
 




THE FOLLOWING DRAWINGS ARE FOR DESIGN INTENT ONLY  
AND ARE NOT TO BE USED FOR CONSTRUCTION.

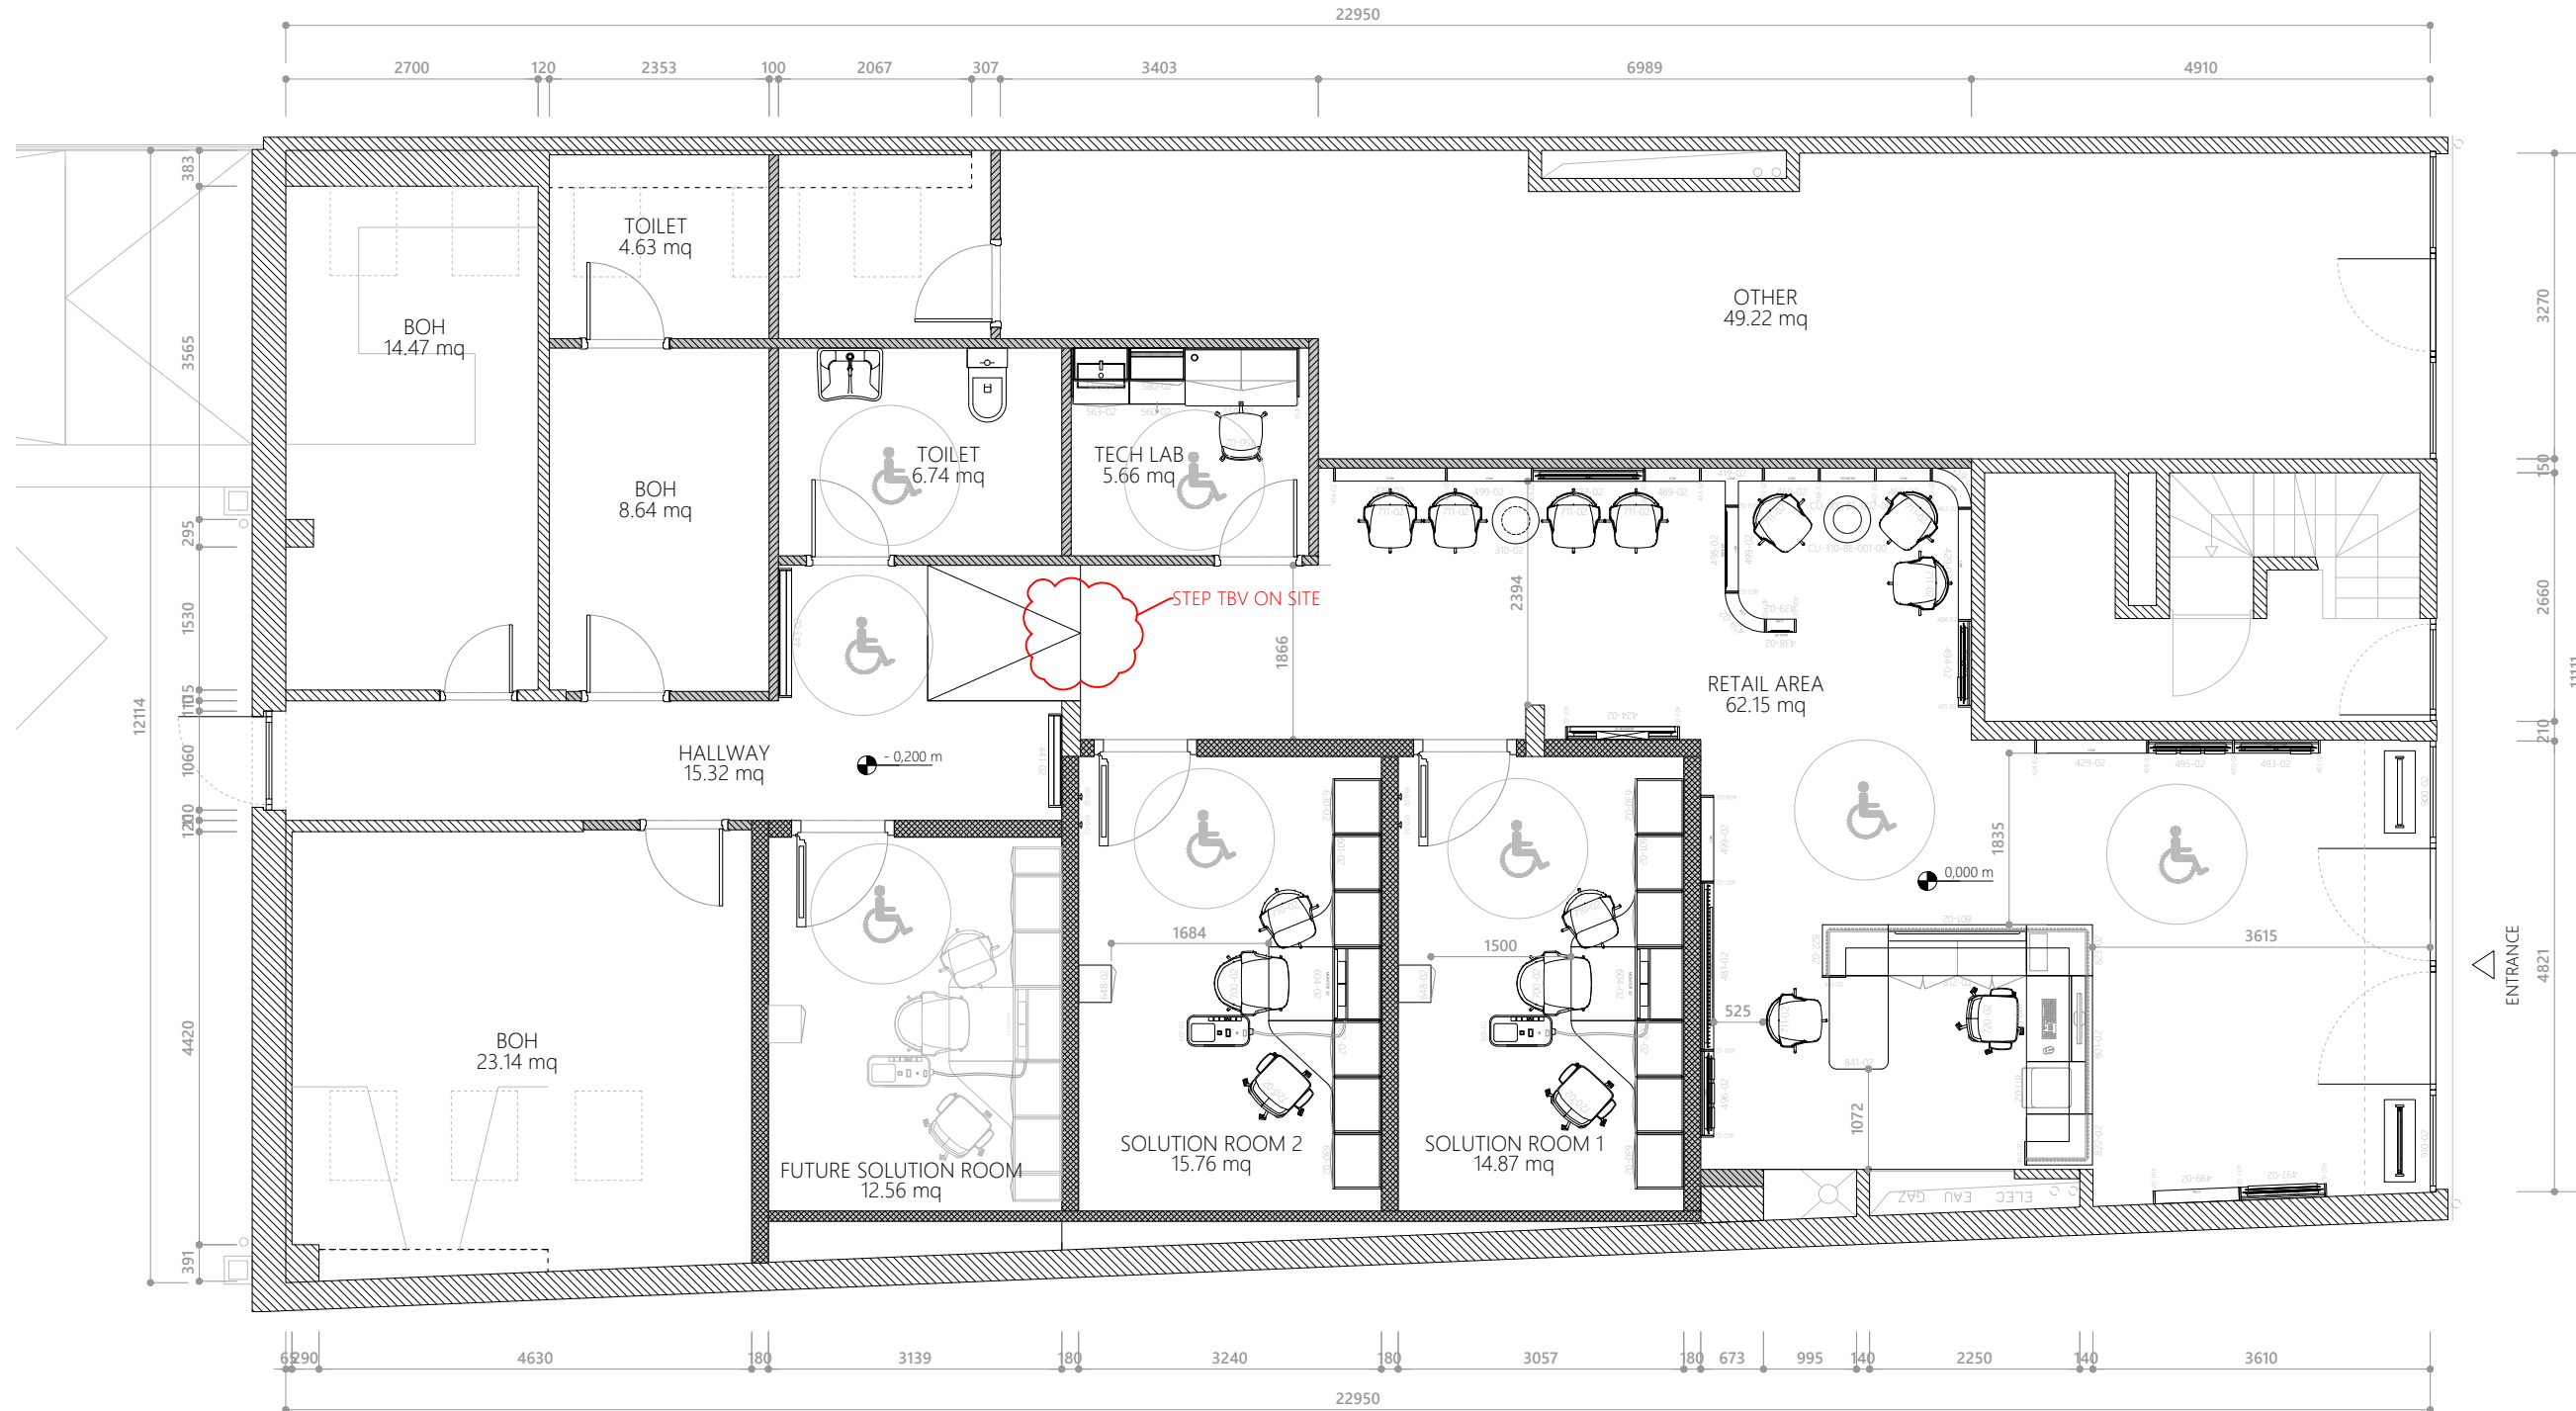

-  EXISTING WALLS
-  NEW WALLS
-  NEW WALLS SOUNDPROOFED

**1** FIXTURE PLAN  
FP1 SCALE 1:80 DIMENSION IN MM

**amplifon**  
PROJECT LOCATION:  
**SCHILDE**  
Turnhoutsebaan 91, 2970 Schilde, Belgium  
PROJECT ID NO.:  
**00714-S05366**

**ampli-care**  
**START**  
REVISION NO.:  
**REV 05**  
STATUS:  
**DDSET**

REVISION LOG:

REV	DATE	DESIGNER
04	07/07/2023	CP
05	21/08/2023	EC

Cleared By: \_\_\_\_\_ Date: \_\_\_\_\_


Store category:  STORE  
 MINI SHOP  
 SIS  
 CORNER

Scope:  NEW  
 REFURBISHMENT  
 RELOCATION  
 LIGHT REFURBISHMENT  
 EXPANSION


TITLE:  
**FIXTURE PLAN**  
SHEET:  
**FP1**

THE FOLLOWING DRAWINGS ARE FOR DESIGN INTENT ONLY  
AND ARE NOT TO BE USED FOR CONSTRUCTION.


CEILING ELEVATIONS TO BE VERIFIED

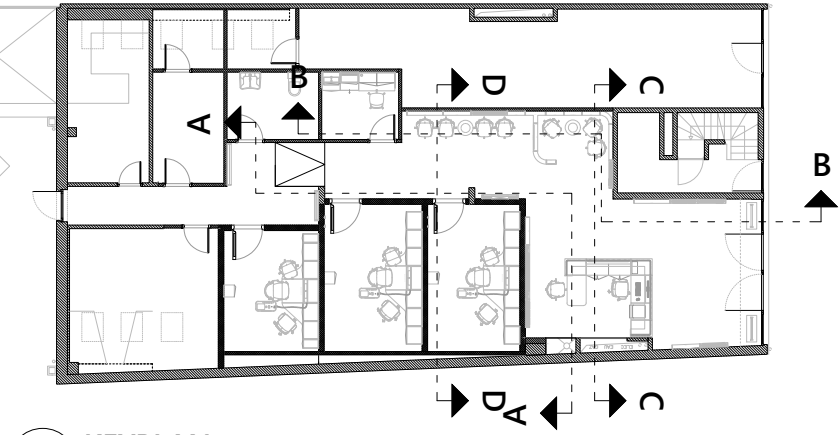

1 KEYPLAN  
EL1 SCALE 1:250 DIMENSION IN MM

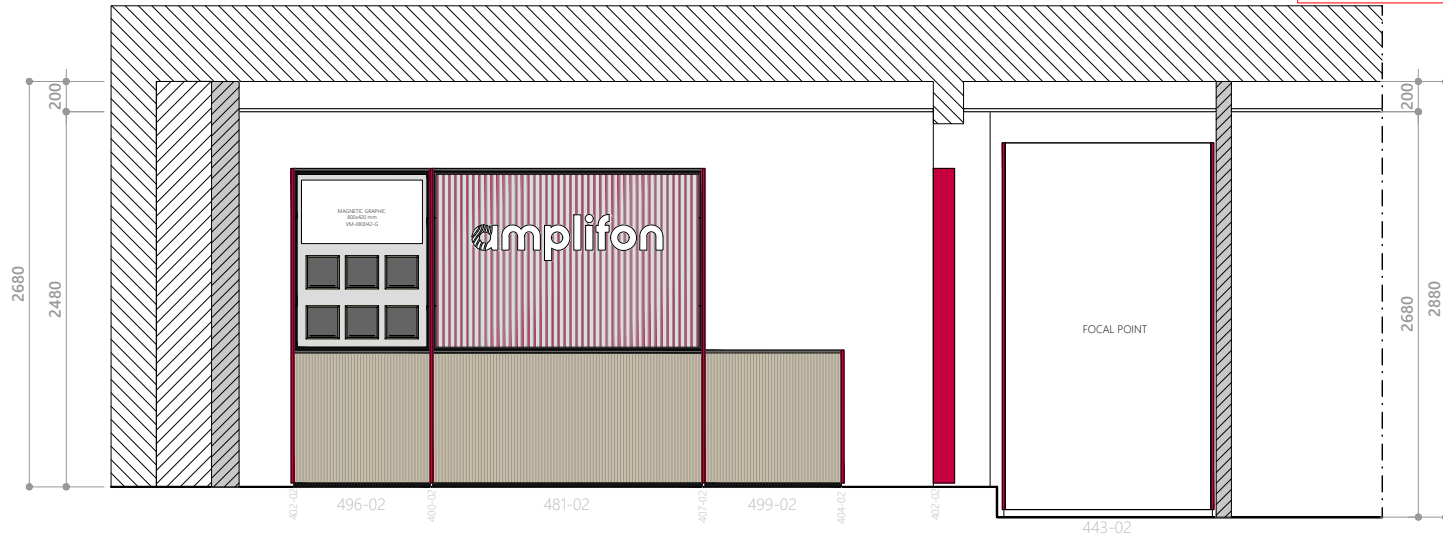


2 ELEVATION AA  
EL1 SCALE 1:50 DIMENSION IN MM

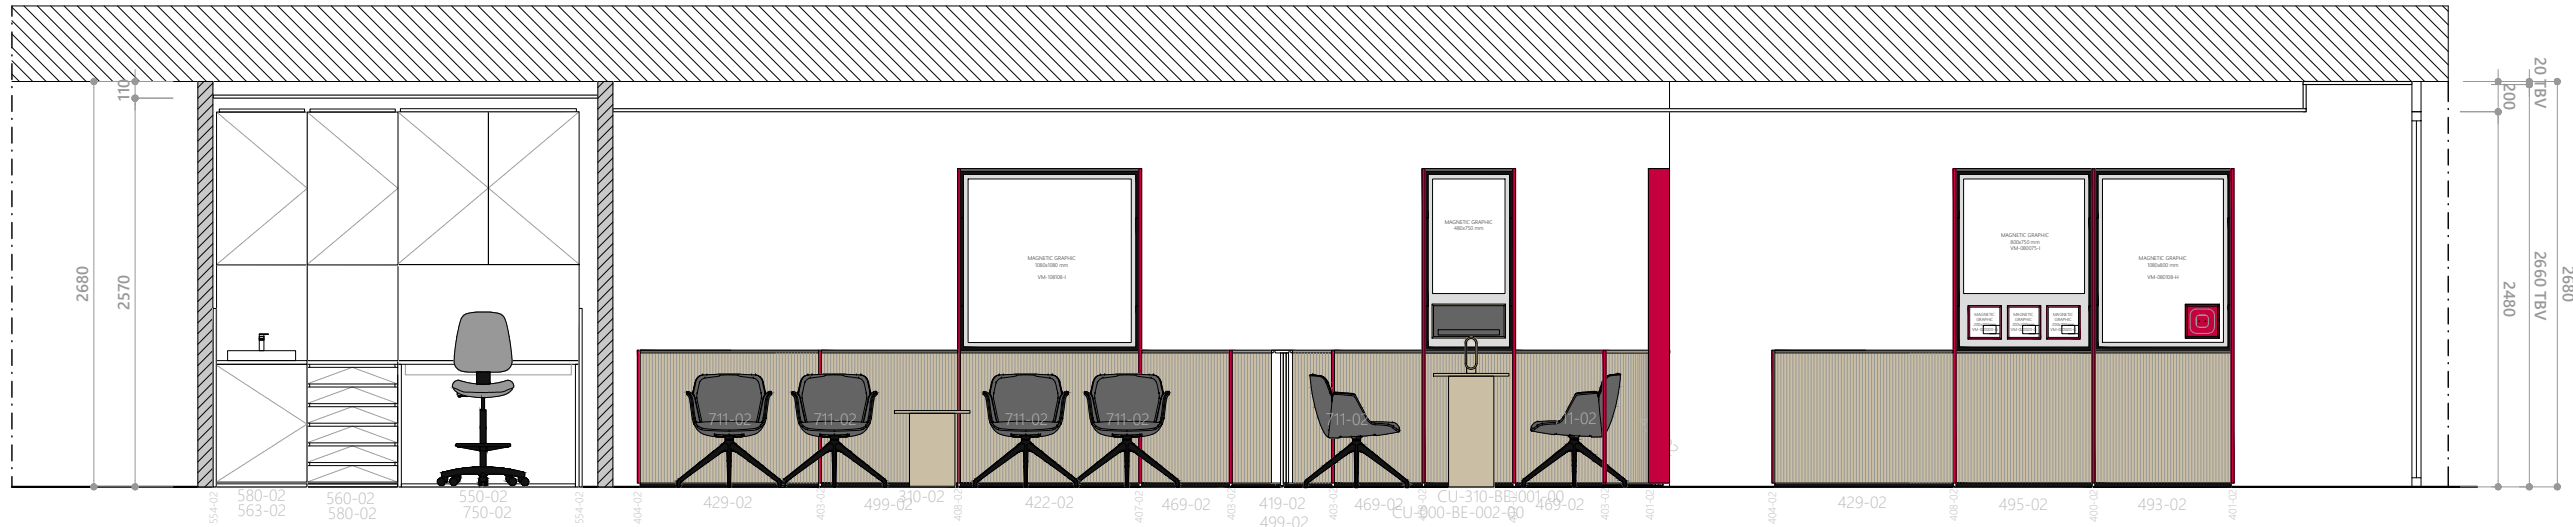

3 ELEVATION BB  
EL1 SCALE 1:50 DIMENSION IN MM



4 ELEVATION CC  
EL1 SCALE 1:50 DIMENSION IN MM

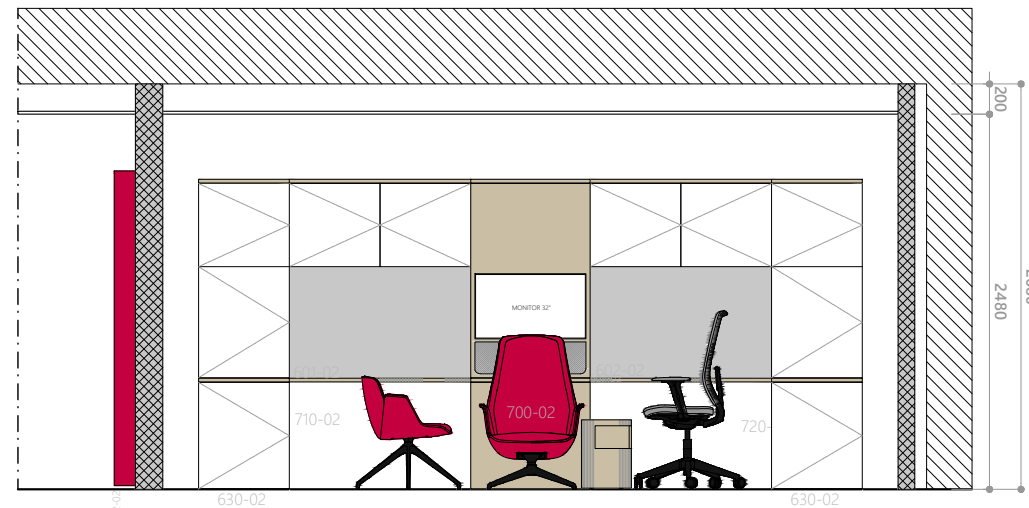

5 ELEVATION DD  
EL1 SCALE 1:50 DIMENSION IN MM

**amplifon**

PROJECT LOCATION:  
**SCHILDE**  
Turnhoutsebaan 91, 2970 Schilde, Belgium

PROJECT ID NO.:  
**00714-S05366**

STORE NO.:

**ampli-care**

**START**

REVISION NO.:

**REV 05**

STATUS:

**DDSET**

REVISION LOG:

REV	DATE	DESIGNER
04	07/07/2023	CP
05	21/08/2023	EC

Cleared By: \_\_\_\_\_ Date: \_\_\_\_\_

Store category:  STORE  
 MINI SHOP  
 SIS  
 CORNER

Scope:  NEW  
 REFURBISHMENT  
 RELOCATION  
 LIGHT REFURBISHMENT  
 EXPANSION

TITLE:


**ELEVATIONS**

SHEET:


**EL1**

THE FOLLOWING DRAWINGS ARE FOR DESIGN INTENT ONLY AND ARE NOT TO BE USED FOR CONSTRUCTION.


CEILING ELEVATIONS TO BE VERIFIED

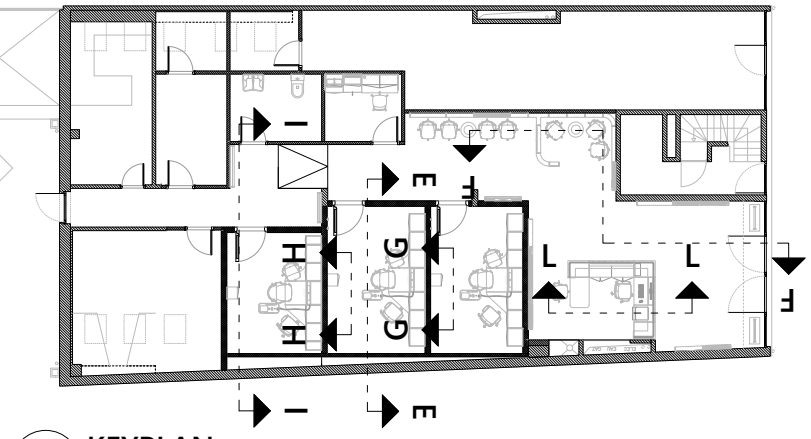


1 KEYPLAN  
EL2 SCALE 1:250 DIMENSION IN MM

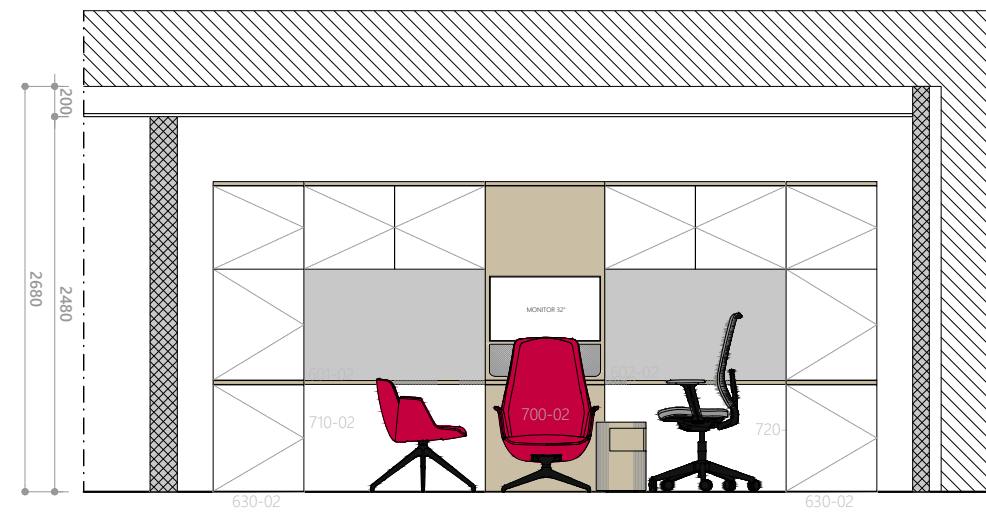


2 ELEVATION EE  
EL2 SCALE 1:50 DIMENSION IN MM

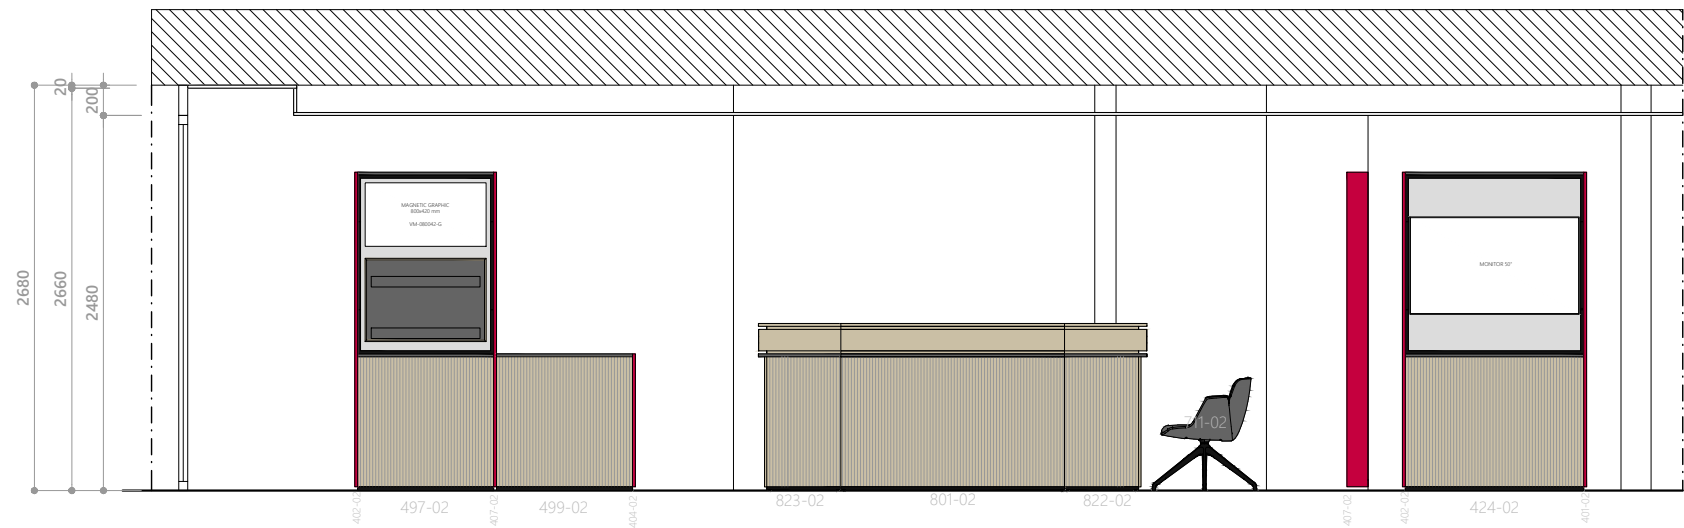


3 ELEVATION FF  
EL2 SCALE 1:50 DIMENSION IN MM

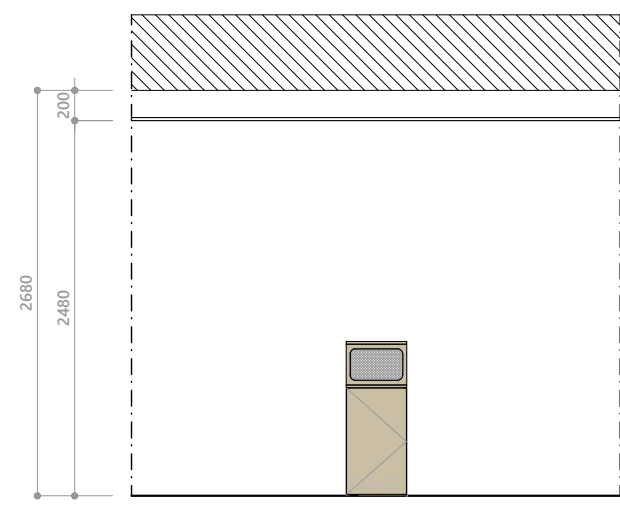


4 ELEVATION GG  
EL2 SCALE 1:50 DIMENSION IN MM

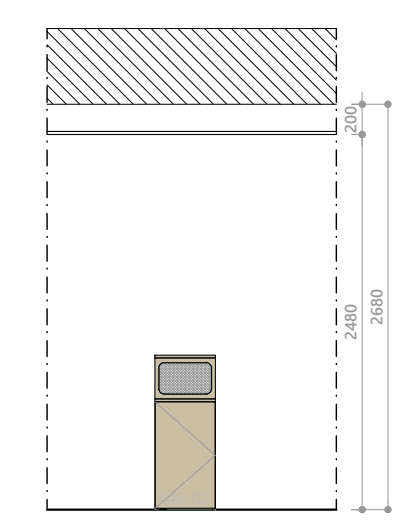

5 ELEVATION HH  
EL2 SCALE 1:50 DIMENSION IN MM

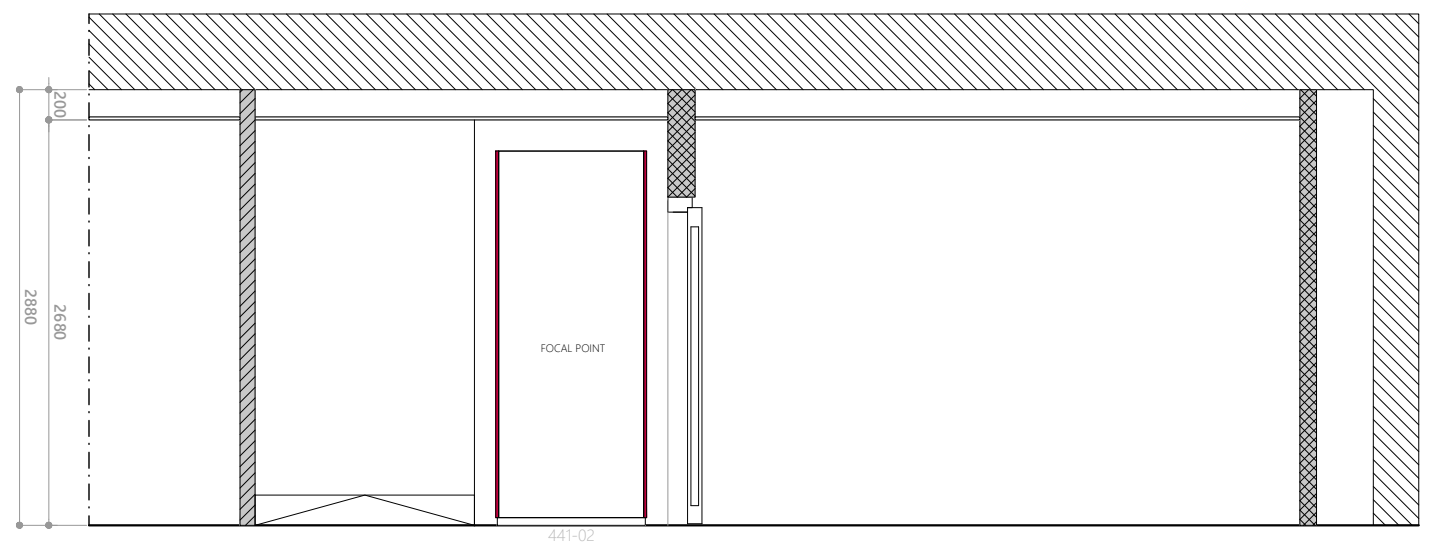

6 ELEVATION II  
EL2 SCALE 1:50 DIMENSION IN MM

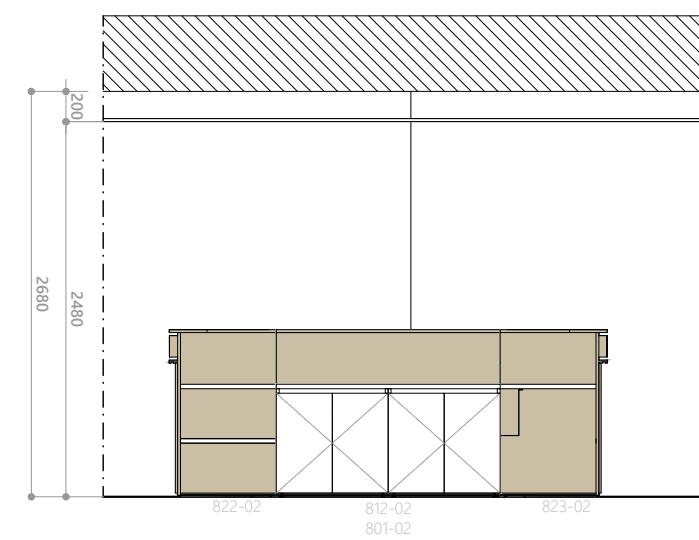

7 ELEVATION LL  
EL2 SCALE 1:50 DIMENSION IN MM

**amplifon**  
PROJECT LOCATION:  
**SCHILDE**  
Turnhoutsebaan 91, 2970 Schilde, Belgium  
PROJECT ID NO.:  
**00714-S05366**

**ampli-care**  
**START**

REVISION NO.:  
**REV 05**  
STATUS:  
**DDSET**


REVISION LOG:

REV	DATE	DESIGNER
04	07/07/2023	CP
05	21/08/2023	EC


Cleared By: \_\_\_\_\_ Date: \_\_\_\_\_  
Store category:  STORE  
 MINI SHOP  
 SIS  
 CORNER  
Scope:  NEW  
 REFURBISHMENT  
 RELOCATION  
 LIGHT REFURBISHMENT  
 EXPANSION

TITLE:  
**ELEVATIONS**  
SHEET:  
**EL2**

THE FOLLOWING DRAWINGS ARE FOR DESIGN INTENT ONLY  
AND ARE NOT TO BE USED FOR CONSTRUCTION.

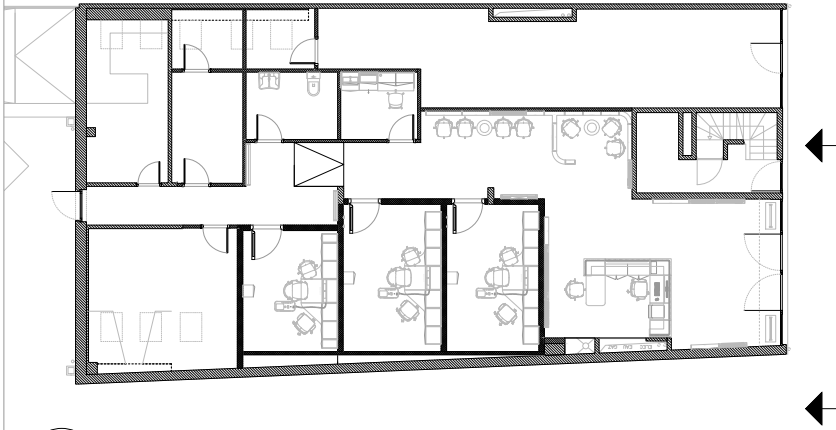

**1 KEYPLAN**  
ST1 SCALE 1:250 DIMENSION IN MM

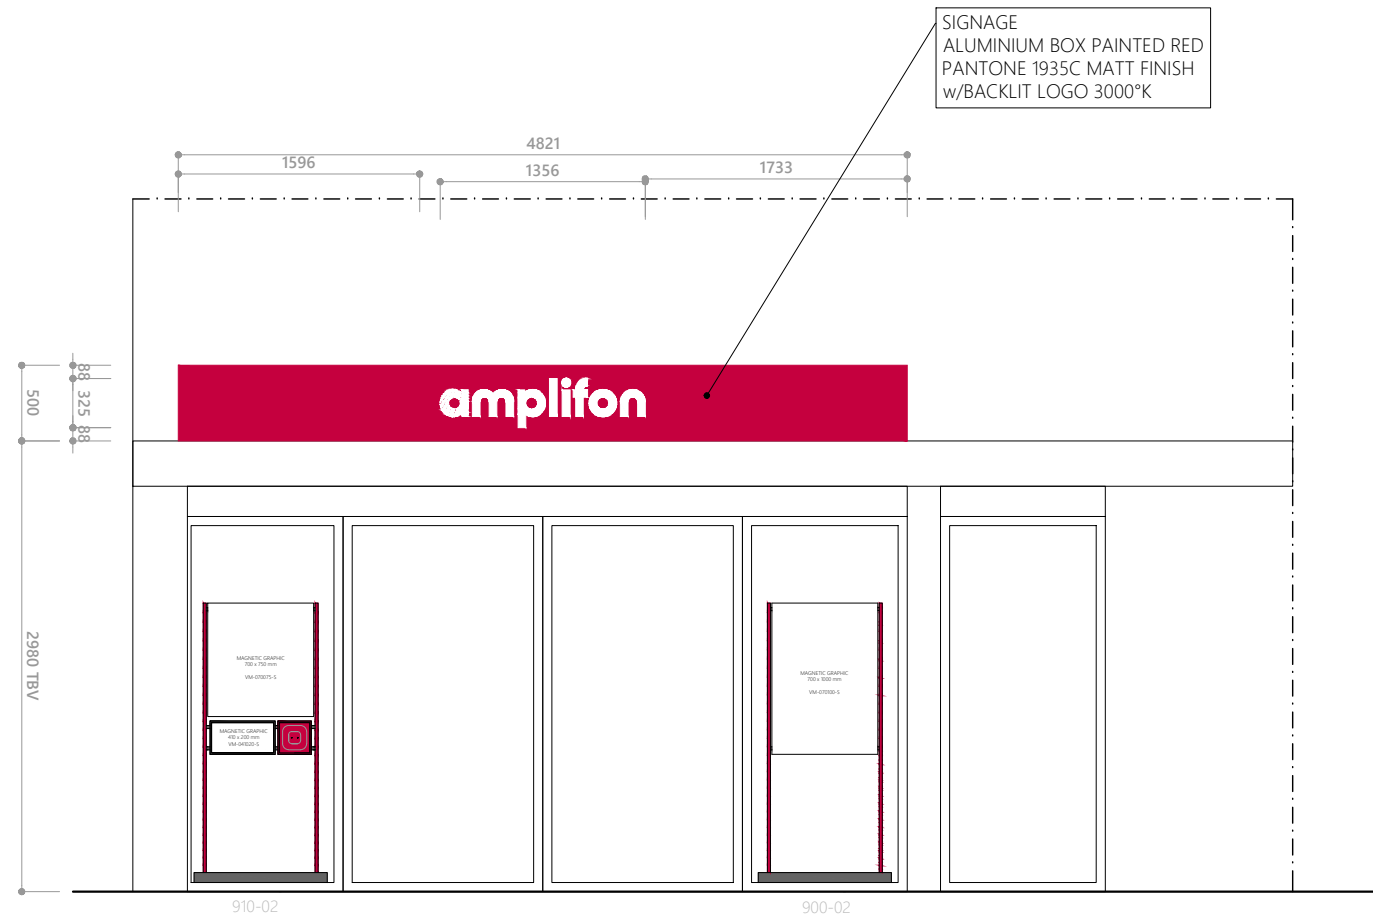

**2 STOREFRONT**  
ST1 SCALE 1:50 DIMENSION IN MM

**amplifon**

PROJECT LOCATION:  
**SCHILDE**  
Turnhoutsebaan 91, 2970 Schilde, Belgium

PROJECT ID NO.:  
**00714-S05366**

STORE NO.:

**ampli-cake**

**START**

REVISION NO.:

**REV 05**

STATUS:

**DDSET**

REVISION LOG:

REV	DATE	DESIGNER
04	07/07/2023	CP
05	21/08/2023	EC

Cleared By: \_\_\_\_\_ Date: \_\_\_\_\_

Store category:  STORE  
 MINI SHOP  
 SIS  
 CORNER

Scope:  NEW  
 REFURBISHMENT  
 RELOCATION  
 LIGHT REFURBISHMENT  
 EXPANSION



TITLE:

**STOREFRONT**


SHEET:

**ST1**

THE FOLLOWING DRAWINGS ARE FOR DESIGN INTENT ONLY  
AND ARE NOT TO BE USED FOR CONSTRUCTION.

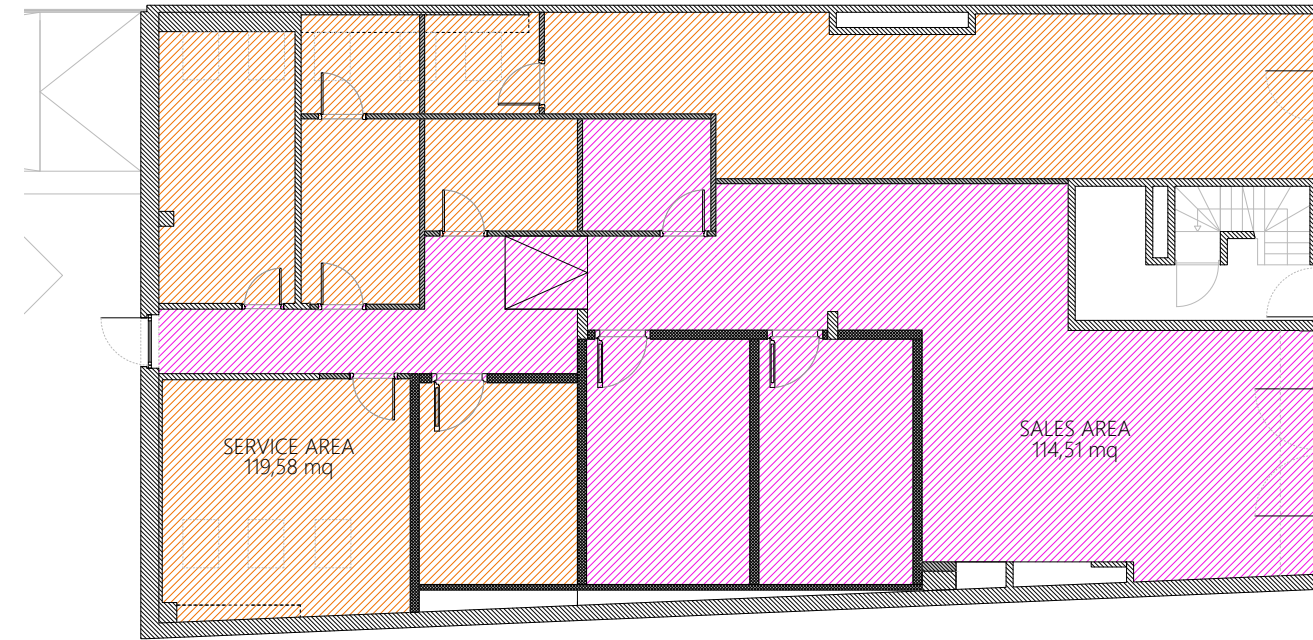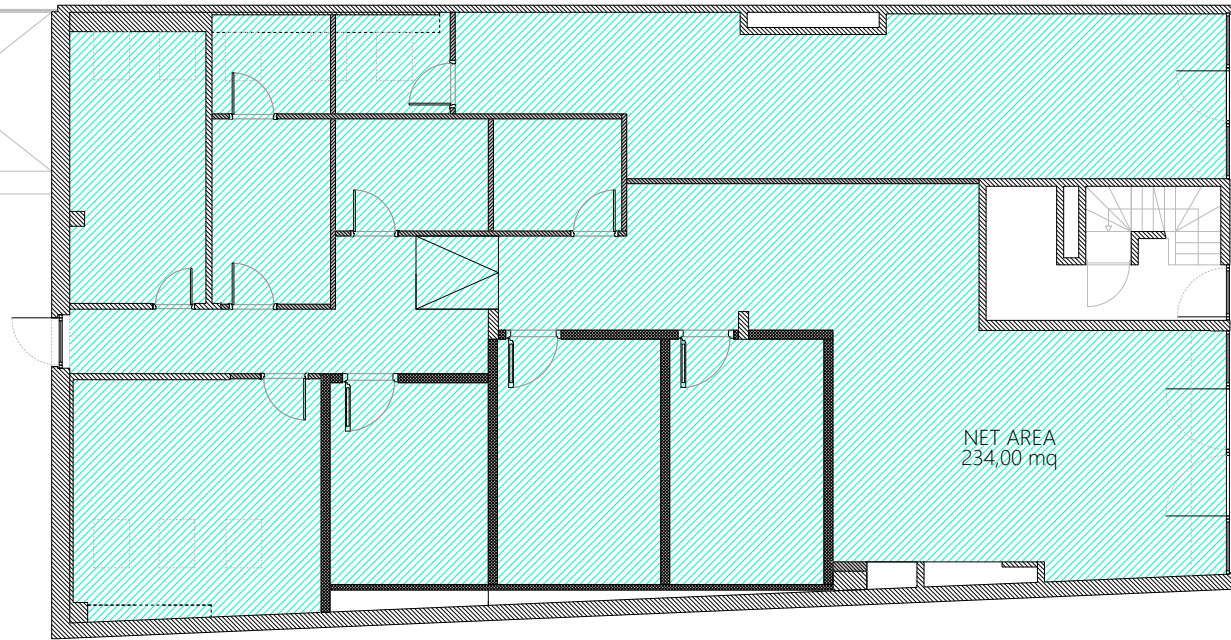


HATCH	DESCRIPTION	AREA
	NET AREA	TOTAL 234,00 sqm
	SALES AREA	TOTAL 114,51 sqm
	SERVICE AREA	TOTAL 119,58 sqm
	RETAIL AREA	TOTAL 78,34 sqm
	SOLUTION ROOM	TOTAL 30,63 sqm
	TECHNICAL LAB	TOTAL 5,66 sqm
	STOCK	TOTAL 12,56 sqm
	TOILET	TOTAL 11,37 sqm
	BOH	TOTAL 95,56 sqm

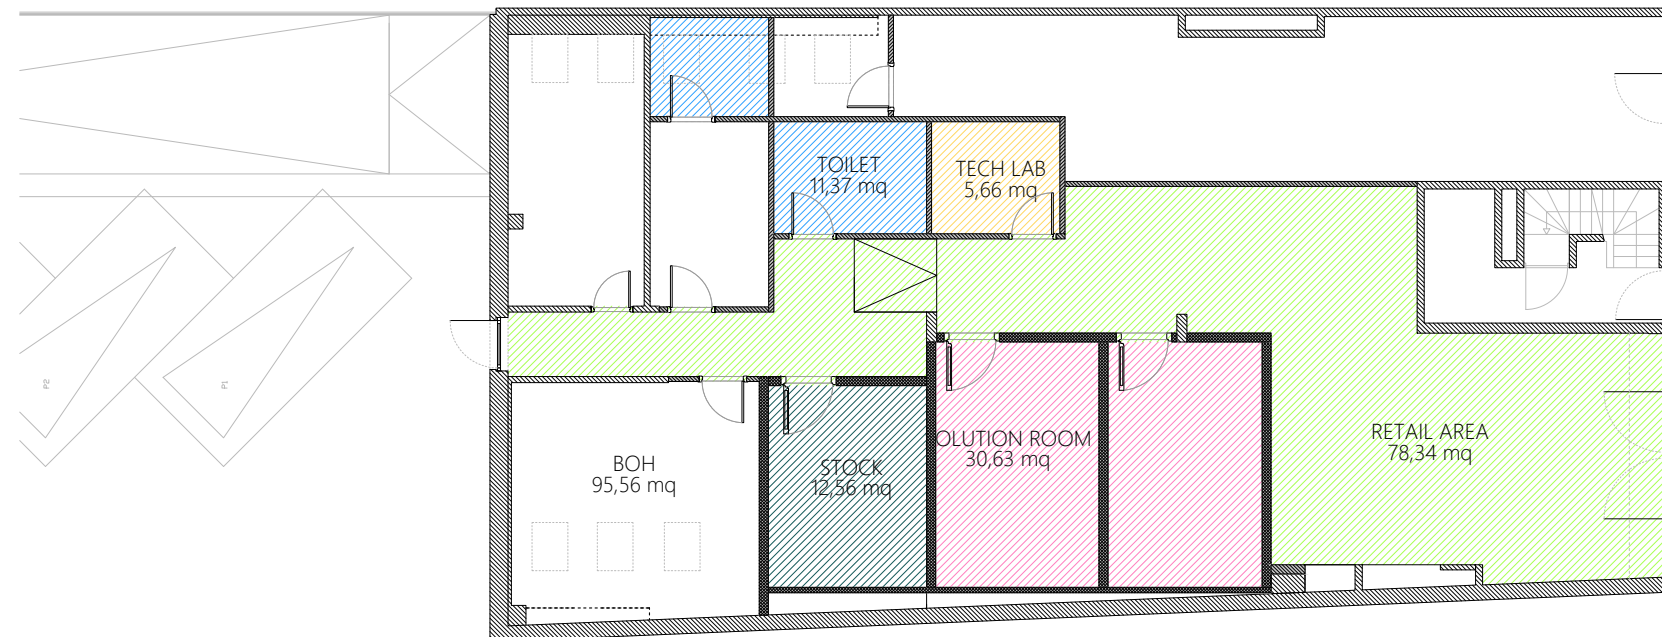

REV	DATE	DESIGNER
04	07/07/2023	CP
05	21/08/2023	EC

THE FOLLOWING DRAWINGS ARE FOR DESIGN INTENT ONLY  
AND ARE NOT TO BE USED FOR CONSTRUCTION.

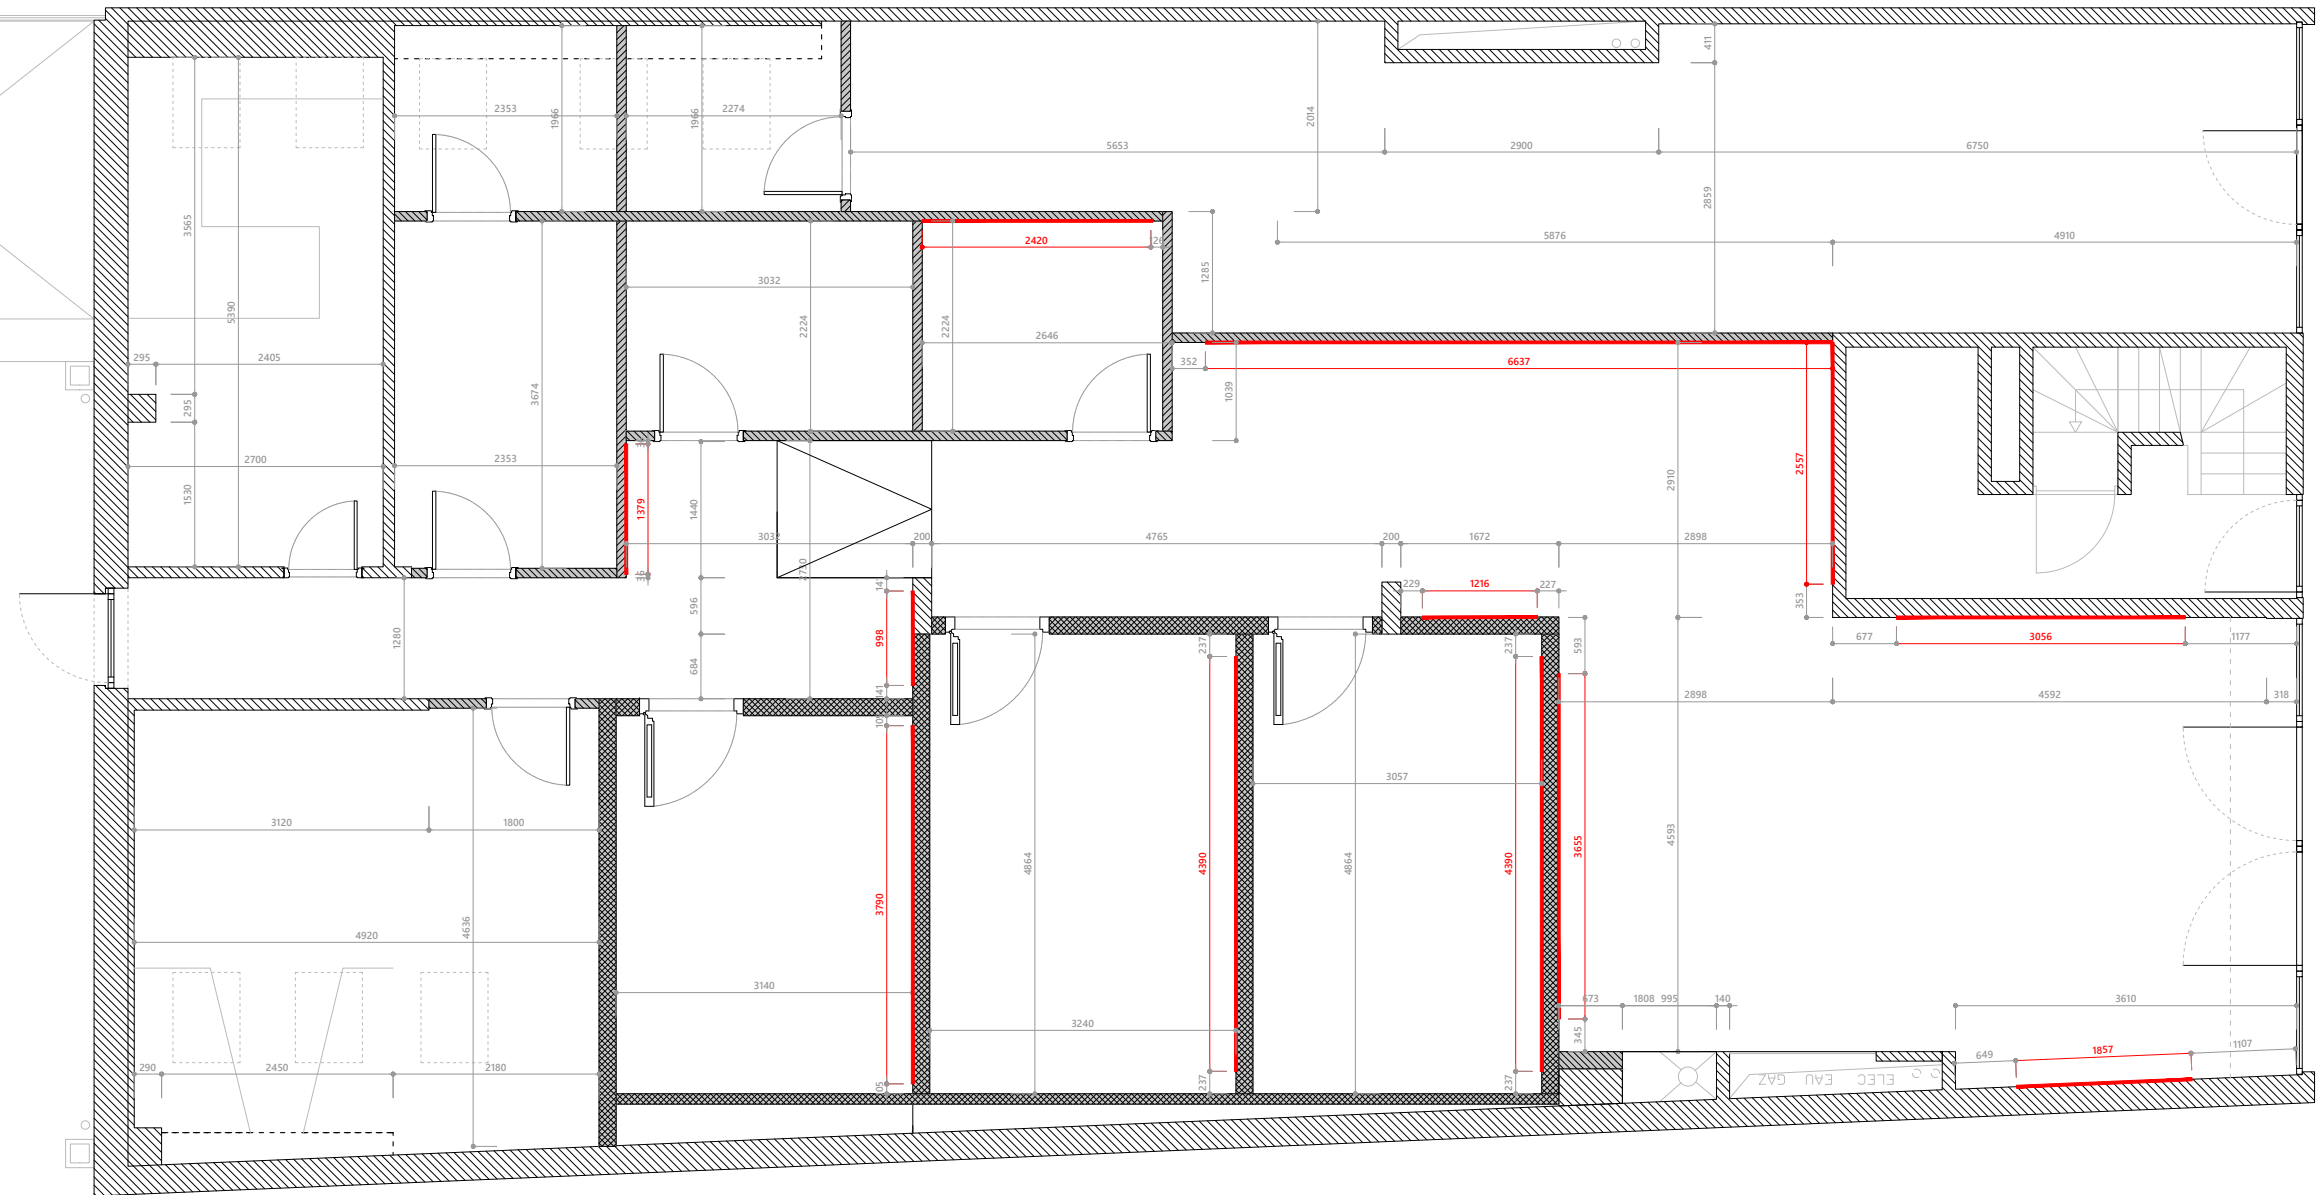

HATCH	CODE	DESCRIPTION	NOTE
		EXISTING WALLS	
		NEW WALLS	
		NEW SOUNDPROOFED WALLS	FULL HEIGHT
		WALL REINFORCEMENT DIGITAL AND FIXTURE INSTALLATION	FULL HEIGHT

**amplifon**  
PROJECT LOCATION:  
**SCHILDE**  
Turnhoutsebaan 91, 2970 Schilde, Belgium  
PROJECT ID NO.:  
**00714-S05366**

**ampli-care**  
**START**

REVISION NO.:  
**REV 05**

STATUS:  
**DDSET**

REVISION LOG:

REV	DATE	DESIGNER
04	07/07/2023	CP
05	21/08/2023	EC

Cleared By: \_\_\_\_\_ Date: \_\_\_\_\_


Store category:  STORE  
 MINI SHOP  
 SIS  
 CORNER

Scope:  NEW  
 REFURBISHMENT  
 RELOCATION  
 LIGHT REFURBISHMENT  
 EXPANSION

TITLE:  
**WALL PLAN**

SHEET:  
**WP1**

THE FOLLOWING DRAWINGS ARE FOR DESIGN INTENT ONLY  
AND ARE NOT TO BE USED FOR CONSTRUCTION.

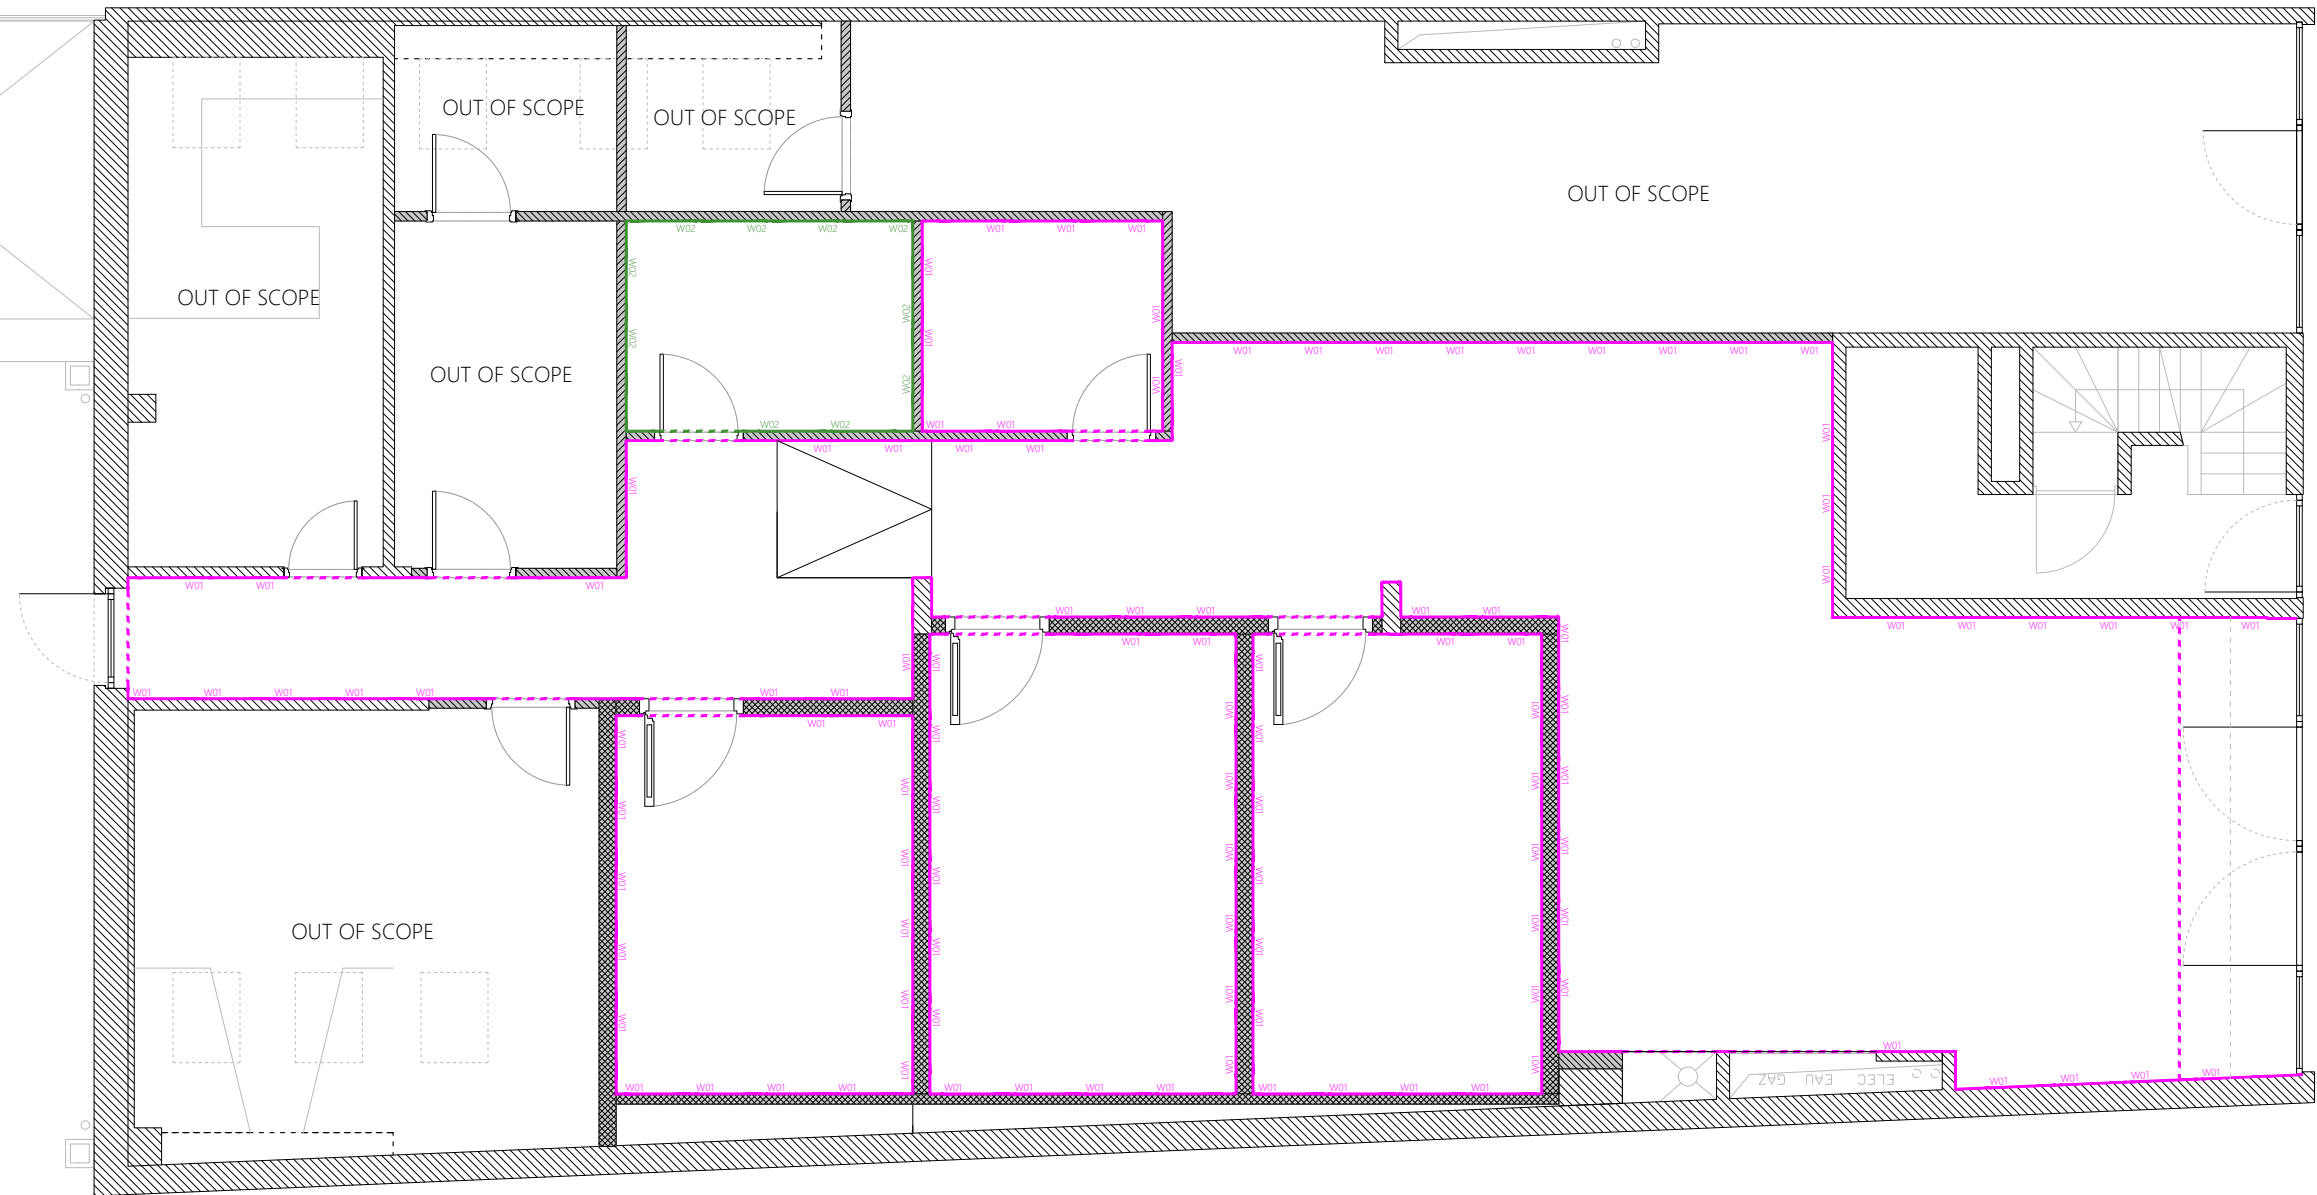

HATCH	CODE	DESCRIPTION	NOTE
	W01	NEW WALL PAINT col. WHITE RAL 9010 MATT FINISH	FULL HEIGHT
	W02	NEW WALL PAINT col. WHITE RAL 9010 ENAMEL FINISH	FULL HEIGHT
	W03	EXISTING WALL FINISH	

**amplifon**  
PROJECT LOCATION:  
**SCHILDE**  
Turnhoutsebaan 91, 2970 Schilde, Belgium  
PROJECT ID NO.:  
**00714-S05366**  
STORE NO.:

**ampli-care**

**START**

REVISION NO.:

**REV 05**

STATUS:

**DDSET**

REVISION LOG:

REV	DATE	DESIGNER
04	07/07/2023	CP
05	21/08/2023	EC

Cleared By: \_\_\_\_\_ Date: \_\_\_\_\_

Store category:  STORE  
 MINI SHOP  
 SIS  
 CORNER

Scope:  NEW  
 REFURBISHMENT  
 RELOCATION  
 LIGHT REFURBISHMENT  
 EXPANSION

TITLE:  
**WALL FINISHES**

SHEET:

**WF1**

THE FOLLOWING DRAWINGS ARE FOR DESIGN INTENT ONLY  
AND ARE NOT TO BE USED FOR CONSTRUCTION.



**amplifon**  
PROJECT LOCATION:  
**SCHILDE**  
Turnhoutsebaan 91, 2970 Schilde, Belgium  
PROJECT ID NO.:  
**00714-S05366**

**ampli-care**

**START**

REVISION NO.:

**REV 05**

STATUS:

**DDSET**

REVISION LOG:

REV	DATE	DESIGNER
04	07/07/2023	CP
05	21/08/2023	EC

Cleared By: \_\_\_\_\_ Date: \_\_\_\_\_

Store category:  STORE  
 MINI SHOP  
 SIS  
 CORNER

Scope:  NEW  
 REFURBISHMENT  
 RELOCATION  
 LIGHT REFURBISHMENT  
 EXPANSION

TITLE:  
**FLOORING FINISHES**


SHEET:

**FF1**

**1 FLOORING FINISHES**  
FF1 SCALE 1:80 DIMENSION IN MM

HATCH	CODE	DESCRIPTION	NOTE
	F01	<b>NEW VINYL TILES</b> ref. GERFLOR - CREATION 70 CLIC col. 1061 PURE CONCRETE MEDIUM dim. 391 x 729 mm	TOTAL mq 130,49
	F02	<b>EXISTING FLOORING</b>	
	F03	<b>ENTRANCE MAT</b> COCONUT DOORMAT col. BLACK	SUPPLY BY GC
	F04	<b>NEW CERAMIC TILES</b> col. WHITE dim. 600 x 600 mm	TOTAL mq 0,66 SUPPLY BY GC
	S01	<b>SKIRTING</b> WOOD SKIRTING col. WHITE RAL 9010 MATT FINISH HEIGHT 50 mm	TOTAL ml 82,59 SUPPLY BY GC

THE FOLLOWING DRAWINGS ARE FOR DESIGN INTENT ONLY  
AND ARE NOT TO BE USED FOR CONSTRUCTION.

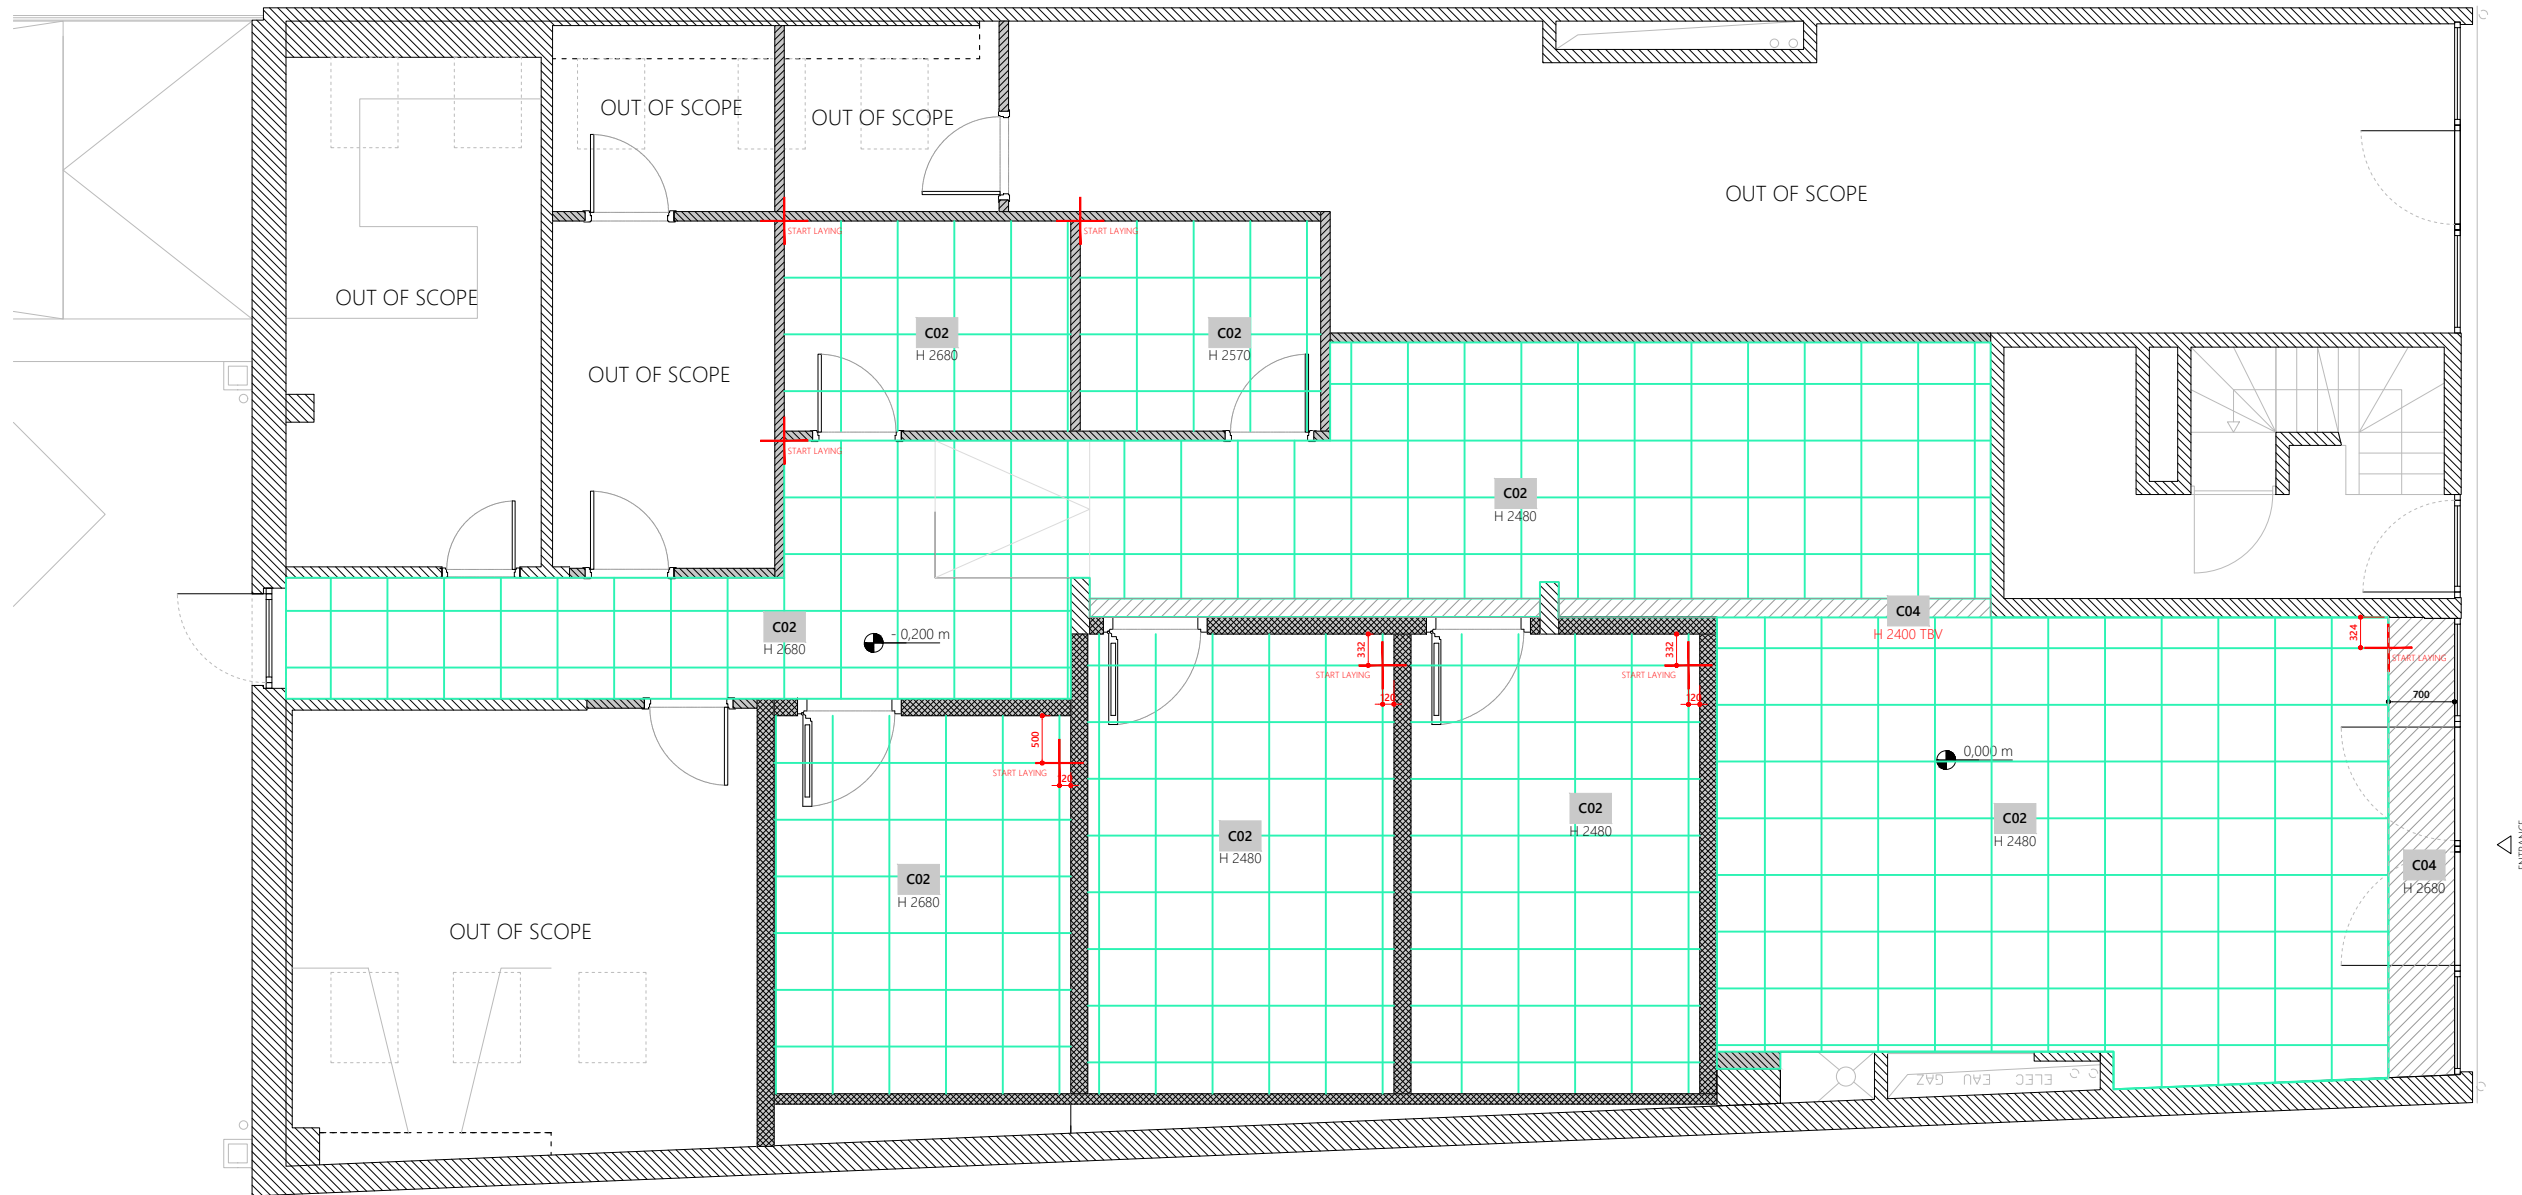

**amplifon**  
PROJECT LOCATION:  
**SCHILDE**  
Turnhoutsebaan 91, 2970 Schilde, Belgium  
PROJECT ID NO.:  
**00714-S05366**

**ampli-care**

**START**

REVISION NO.:

**REV 05**

STATUS:

**DDSET**

REVISION LOG:

REV	DATE	DESIGNER
04	07/07/2023	CP
05	21/08/2023	EC

Cleared By: \_\_\_\_\_ Date: \_\_\_\_\_

Store category:  STORE  
 MINI SHOP  
 SIS  
 CORNER

Scope:  NEW  
 REFURBISHMENT  
 RELOCATION  
 LIGHT REFURBISHMENT  
 EXPANSION


TITLE: **REFLECTED CEILING PLAN**

SHEET:

**RCP1**

HATCH	CODE	DESCRIPTION	NOTE
	C01	NEW GWB CEILING PAINTED WHITE RAL 9010 MATT FINISH	TOTAL mq 0,00
	C02	NEW ACT CEILING col. WHITE RAL 9010 dim. 600 x 600 mm	TOTAL mq 115,99
	C03	CEILING REINFORCEMENT LIGHTING INSTALLATION	CIRCULAR LIGHTING WEIGHT 18 kg
	C04	EXISTING CEILING PAINTED WHITE RAL 9010 MATT FINISH	TOTAL mq 5,26

THE FOLLOWING DRAWINGS ARE FOR DESIGN INTENT ONLY AND ARE NOT TO BE USED FOR CONSTRUCTION.

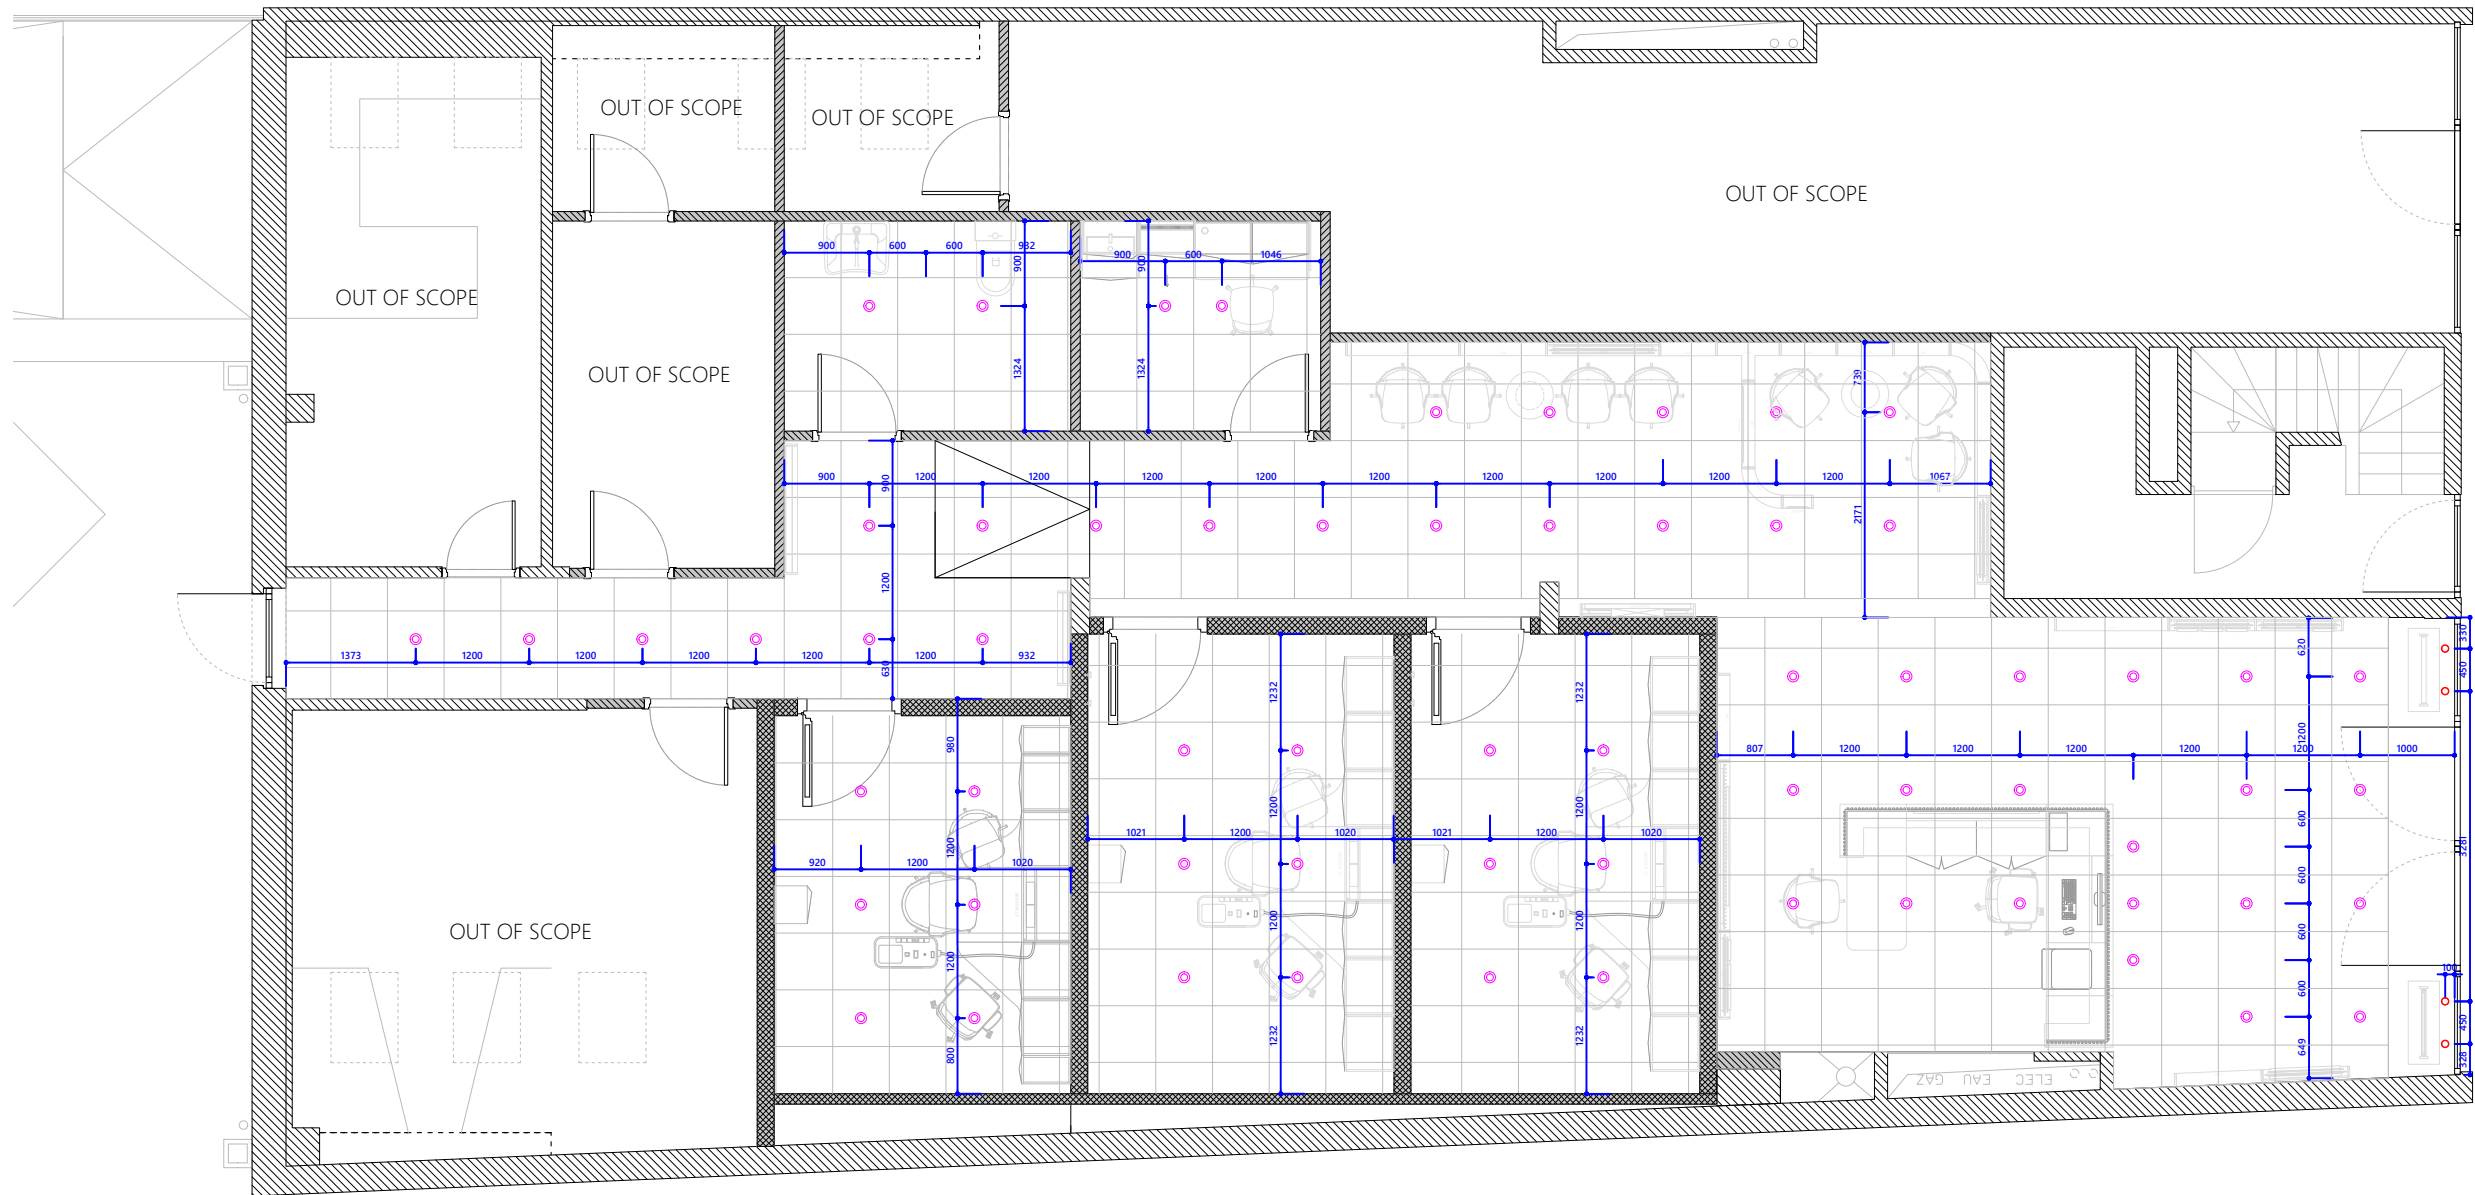

**amplifon**  
 PROJECT LOCATION:  
**SCHILDE**  
 Turnhoutsebaan 91, 2970 Schilde, Belgium  
 PROJECT ID NO.:  
**00714-S05366**  
 STORE NO.:

**ampli-care**

**START**

REVISION NO.:

**REV 05**

STATUS:

**DDSET**

REVISION LOG:

REV	DATE	DESIGNER
04	07/07/2023	CP
05	21/08/2023	EC

Cleared By: \_\_\_\_\_ Date: \_\_\_\_\_

Store category:  STORE  
 MINI SHOP  
 SIS  
 CORNER

Scope:  NEW  
 REFURBISHMENT  
 RELOCATION  
 LIGHT REFURBISHMENT  
 EXPANSION


TITLE:  
**LIGHTING PLAN**

SHEET:

**LP1**

SYMBOL	DESCRIPTION	NOTE			
	<b>TRACK</b> 3 PHASE TRACK SURFACE MOUNTED col. WHITE MATT FINISH dim. L 2000 mm			<b>SUSPENDED LAMPS</b> Ø 350 mm 3000°K	LIGHTING INSTALLATION HEIGHT H 1900 mm FFL TO LOWER LIGHT
	<b>TRACK</b> 3 PHASE TRACK SURFACE MOUNTED col. WHITE MATT FINISH dim. L 3000 mm			<b>SUSPENDED CIRCULAR LIGHTING</b> SUSPENDED DOUBLE EMISSION - Ø 900 mm 3000°K - CRI>80 - CASAMBI ONBOARD - 90W WOOD FINISH	
<b>ACCESSORIES</b>	<b>ACCESSORIES</b> LIVE END WHITE FINISH END CAP WHITE FINISH JOINING CONNECTOR WHITE FINISH L JOINT WHITE FINISH			<b>CYLINDRICAL SPOTLIGHT CEILING MOUNTED</b>	
	<b>SPOTLIGHT</b> col. WHITE + INTRACK ADAPTER w/INTEGRATED DRIVER col. BLACK			<b>ROUND RECESSED SPOTLIGHT</b>	
	<b>HONEYCOMB</b>			<b>NEW ACT CEILING</b> AS PER RCP PLAN	LIGHTING POSITION LINKED TO ACT CEILING

THE FOLLOWING DRAWINGS ARE FOR DESIGN INTENT ONLY AND ARE NOT TO BE USED FOR CONSTRUCTION.

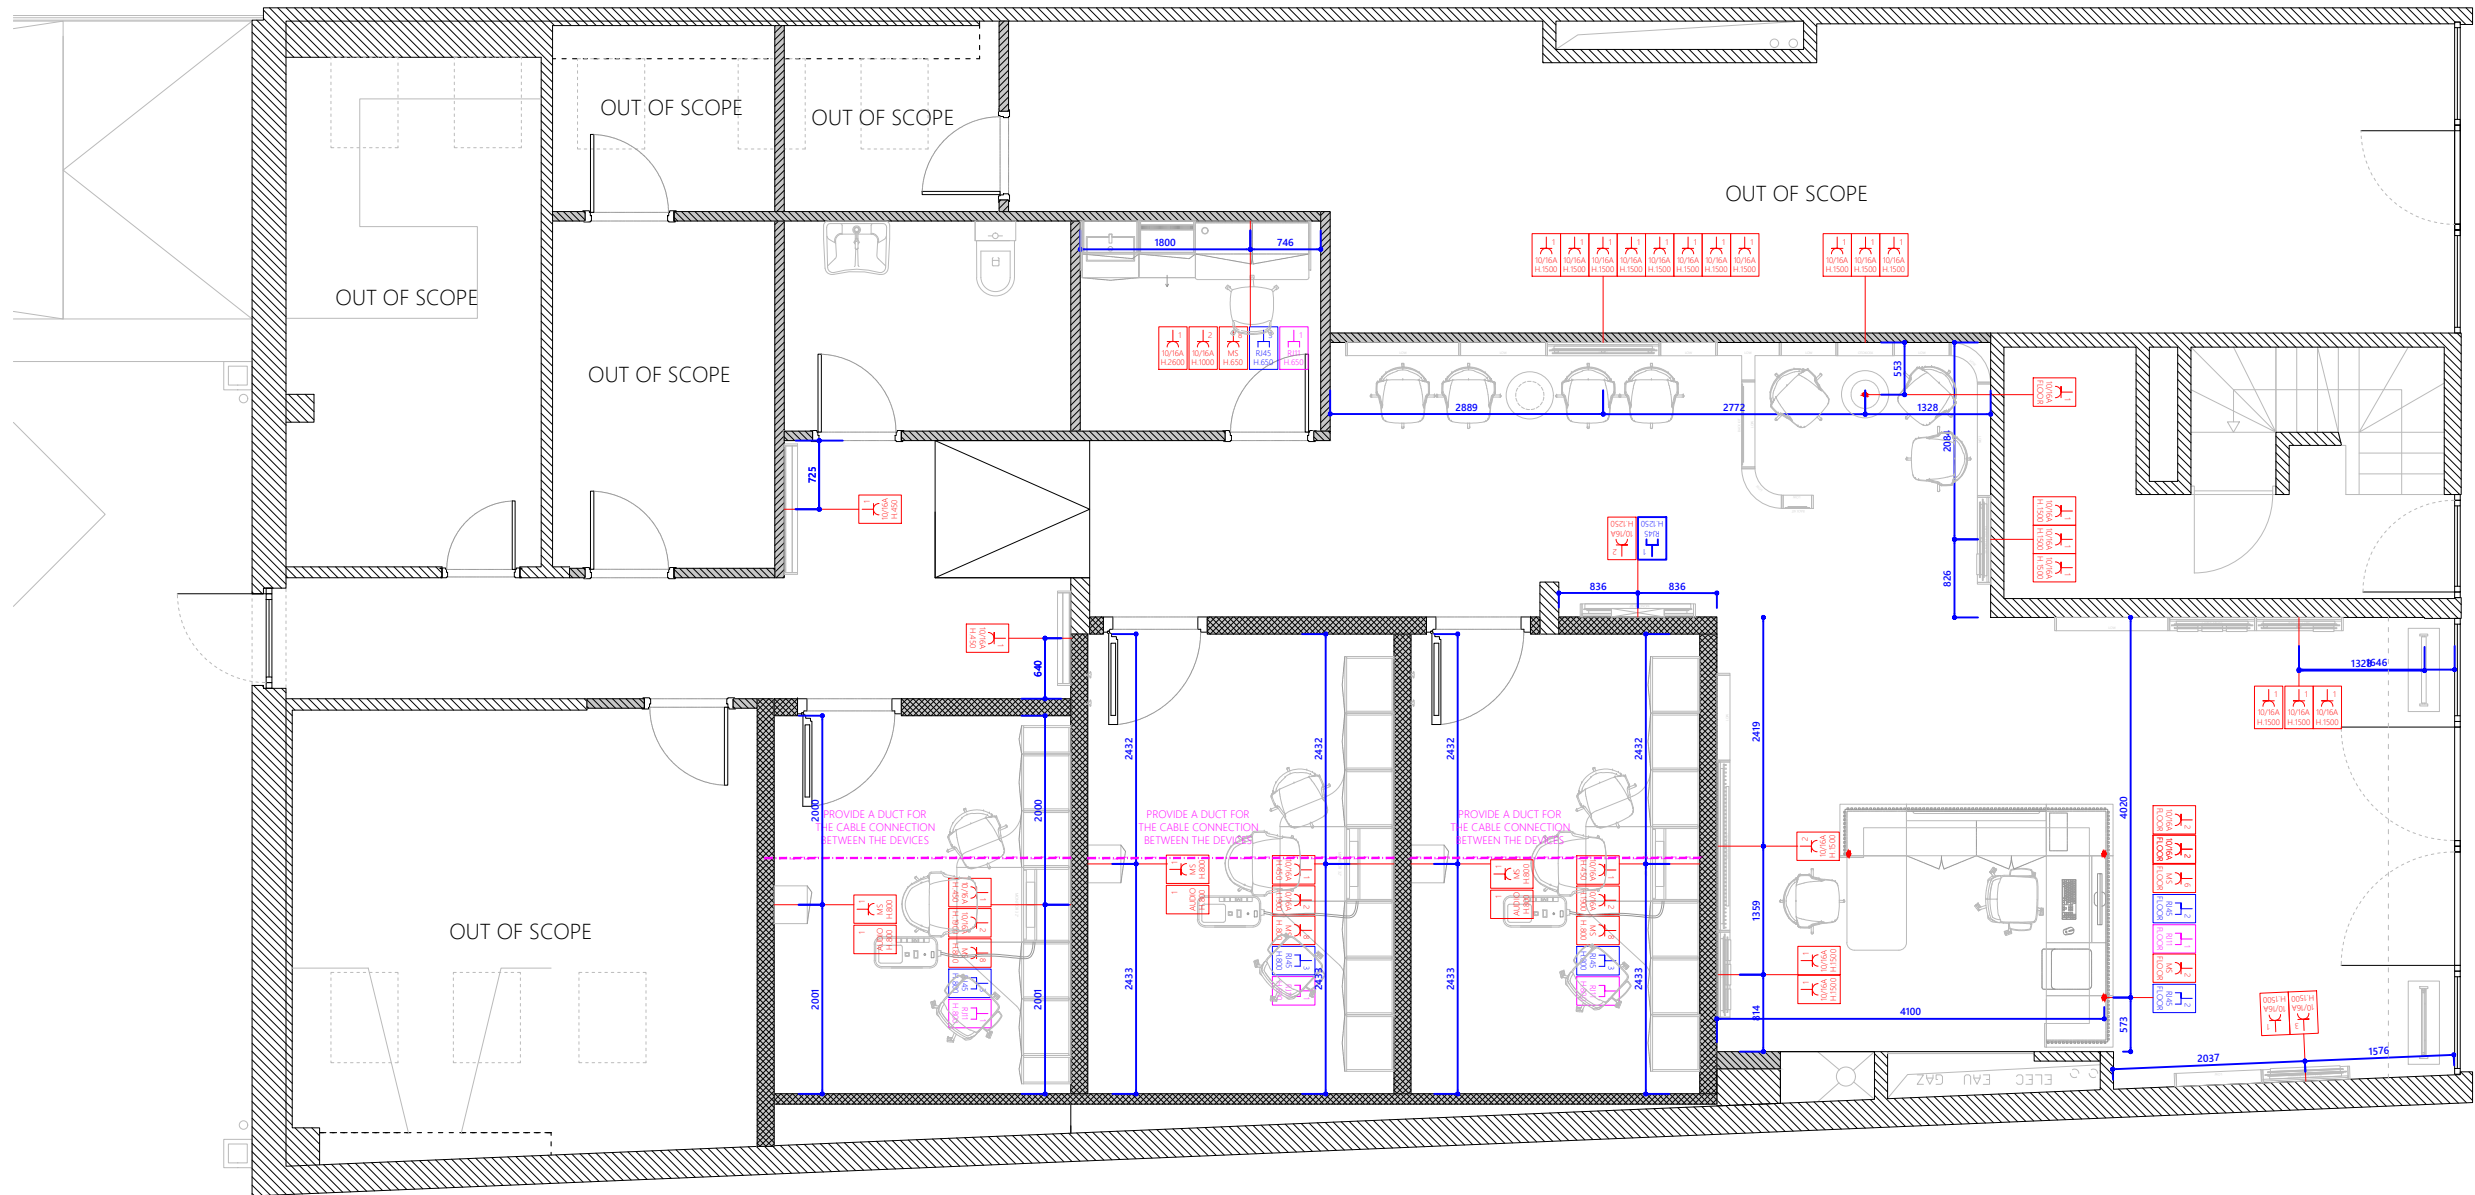

**amplifon**  
 PROJECT LOCATION:  
**SCHILDE**  
 Turnhoutsebaan 91, 2970 Schilde, Belgium  
 PROJECT ID NO.:  
**00714-S05366**  
 STORE NO.:

**ampli-care**

**START**

REVISION NO.:

**REV 05**

STATUS:

**DDSET**

REVISION LOG:

REV	DATE	DESIGNER
04	07/07/2023	CP
05	21/08/2023	EC

Cleared By: \_\_\_\_\_ Date: \_\_\_\_\_











- Store category:
- STORE
  - MINI SHOP
  - SIS
  - CORNER

- Scope:
- NEW
  - REFURBISHMENT
  - RELOCATION
  - LIGHT REFURBISHMENT
  - EXPANSION

TITLE:  
**ELECTRICAL PLAN**


SHEET:

**ELEC1**


TAG	DESCRIPTION	NOTE	
 	<b>POWER OUTLET</b> WALL RECESSED POWER OUTLET	10/16A MS POWER OUTLET 10/16A POWER OUTLET SCHUKO MULTISTANDARD	 FIXTURE LED POWER OUTLET  LIGHTBOX POWER OUTLET  LOGO POWER OUTLET  APPLIQUES FIXTURE POWER OUTLET  MONITOR POWER OUTLET
	<b>DATA OUTLET</b> WALL RECESSED DATA OUTLET		
	<b>PHONE OUTLET</b> WALL RECESSED PHONE OUTLET		
N.B. ELECTRICAL PLAN ONLY FOR FIXTURES LIGHTING POWER SUPPLY SERVICE POWER SOCKET ARE NOT MARKED IN THIS PLAN			 SOCKET NUMBER POWER OUTLET TYPE INSTALLATION HEIGHT

THE FOLLOWING DRAWINGS ARE FOR DESIGN INTENT ONLY  
AND ARE NOT TO BE USED FOR CONSTRUCTION.


CEILING ELEVATIONS TO BE VERIFIED

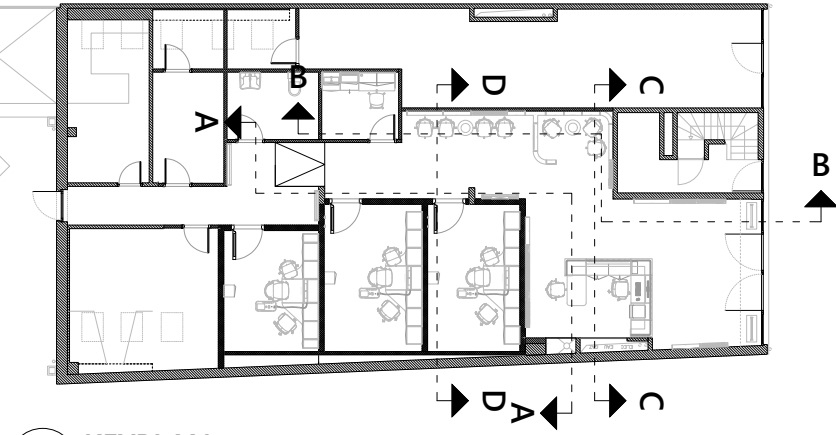


1 KEYPLAN  
ELEC2 SCALE 1:250 DIMENSION IN MM

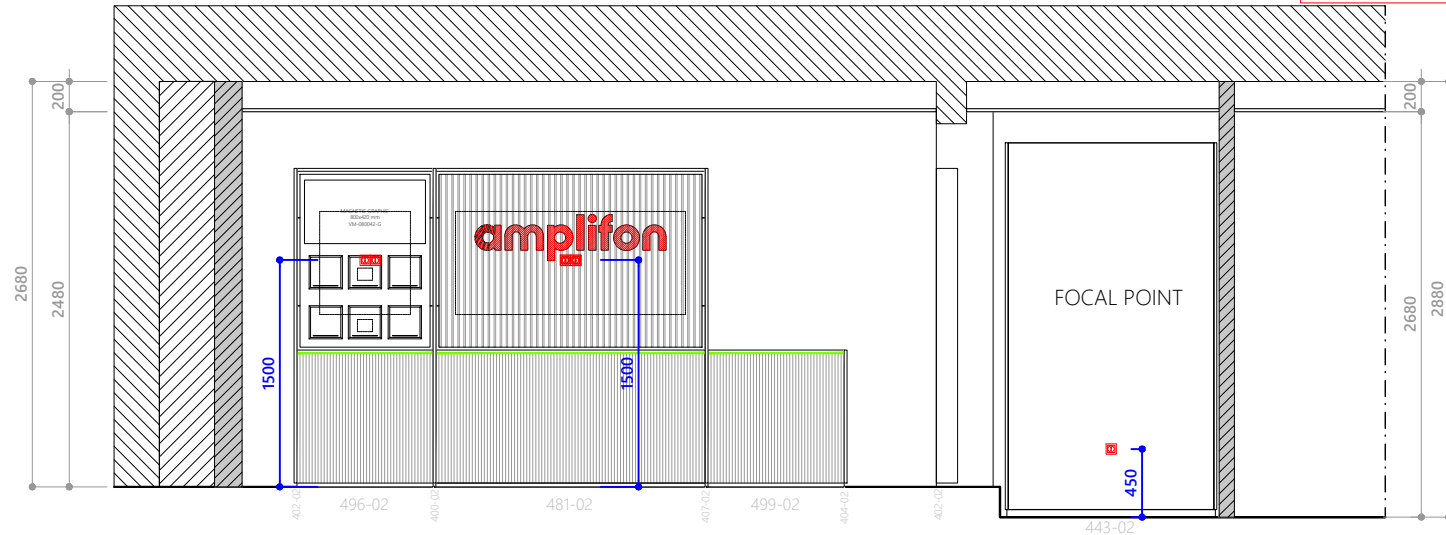


2 ELEVATION AA  
ELEC2 SCALE 1:50 DIMENSION IN MM

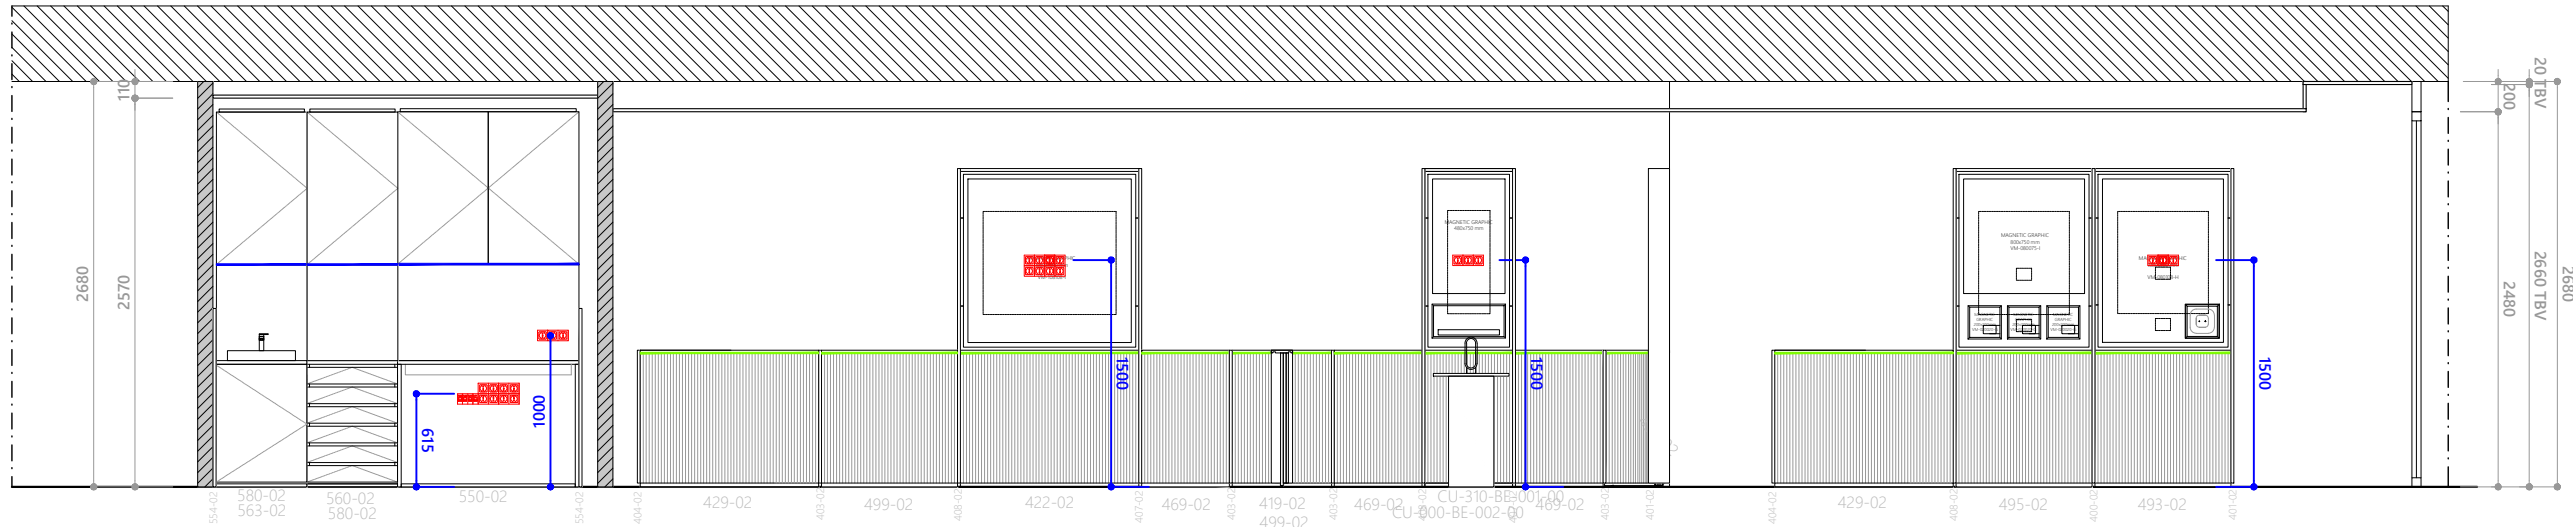

3 ELEVATION BB  
ELEC2 SCALE 1:50 DIMENSION IN MM

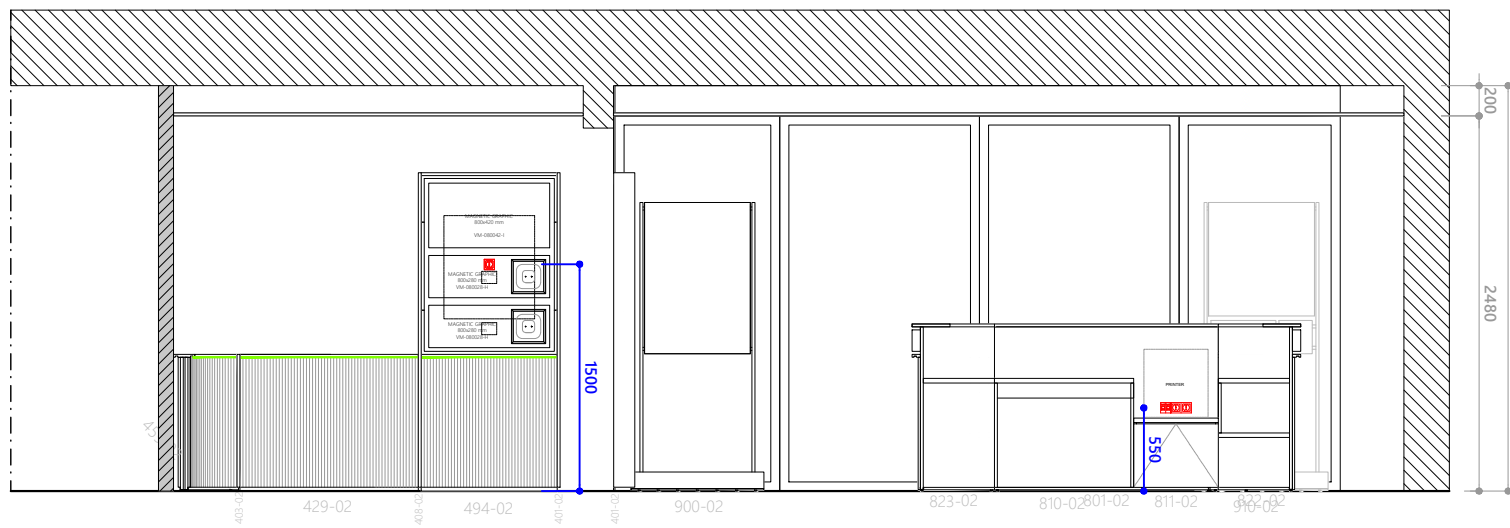

4 ELEVATION CC  
ELEC2 SCALE 1:50 DIMENSION IN MM

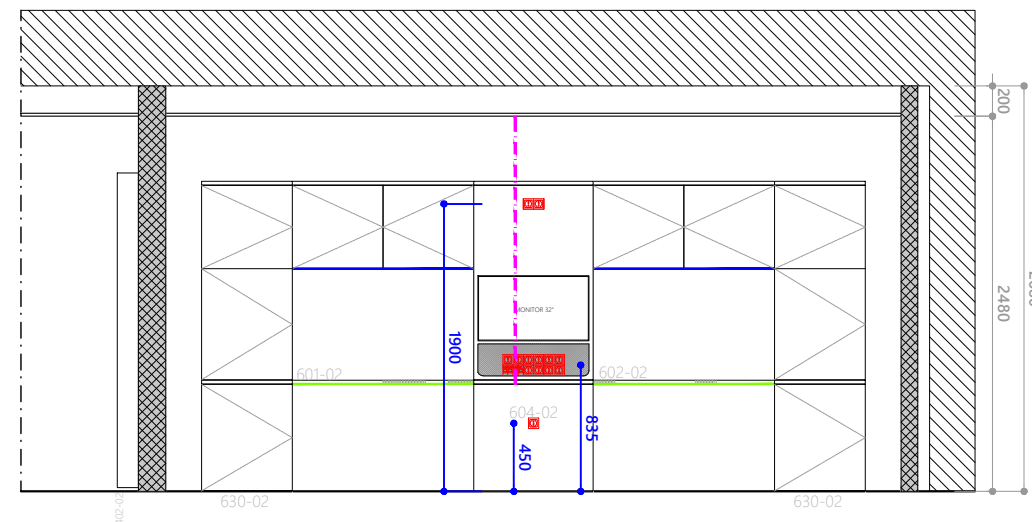

5 ELEVATION DD  
ELEC2 SCALE 1:50 DIMENSION IN MM

**amplifon**

PROJECT LOCATION:  
**SCHILDE**  
Turnhoutsebaan 91, 2970 Schilde, Belgium

PROJECT ID NO.:  
**00714-S05366**

**ampli-care**

**START**

REVISION NO.:

**REV 05**

STATUS:

**DDSET**

REVISION LOG:

REV	DATE	DESIGNER
04	07/07/2023	CP
05	21/08/2023	EC

Cleared By: \_\_\_\_\_ Date: \_\_\_\_\_

Store category:  STORE  
 MINI SHOP  
 SIS  
 CORNER

Scope:  NEW  
 REFURBISHMENT  
 RELOCATION  
 LIGHT REFURBISHMENT  
 EXPANSION


TITLE: **ELECTRICAL ELEVATIONS**

SHEET:


**ELEC2**

THE FOLLOWING DRAWINGS ARE FOR DESIGN INTENT ONLY AND ARE NOT TO BE USED FOR CONSTRUCTION.


CEILING ELEVATIONS TO BE VERIFIED

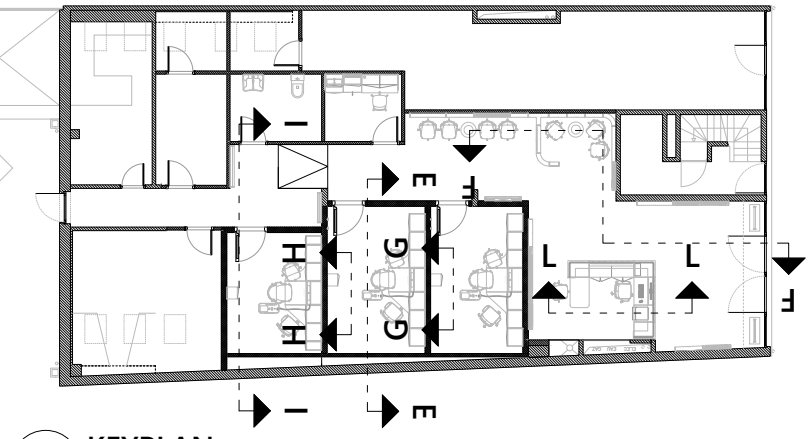


1 KEYPLAN  
ELEC3 SCALE 1:250 DIMENSION IN MM

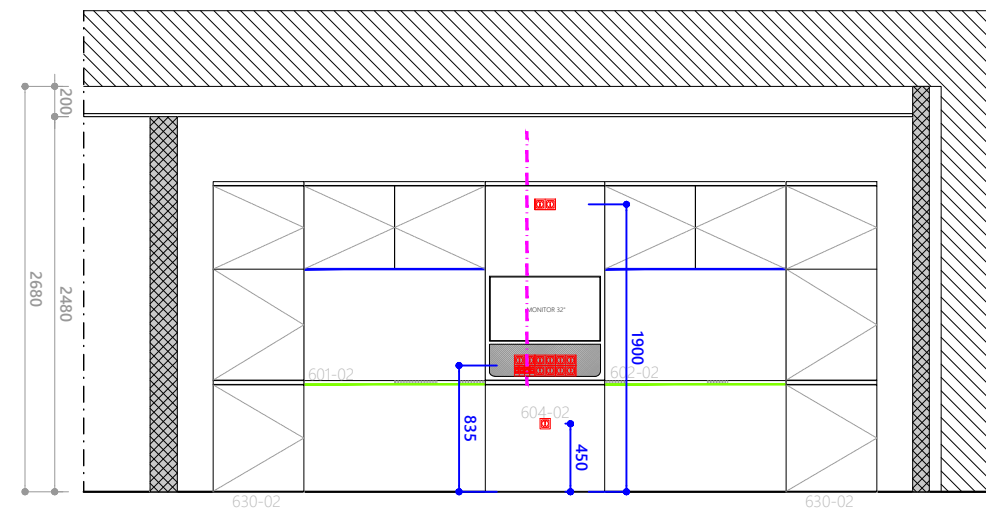


2 ELEVATION EE  
ELEC3 SCALE 1:50 DIMENSION IN MM

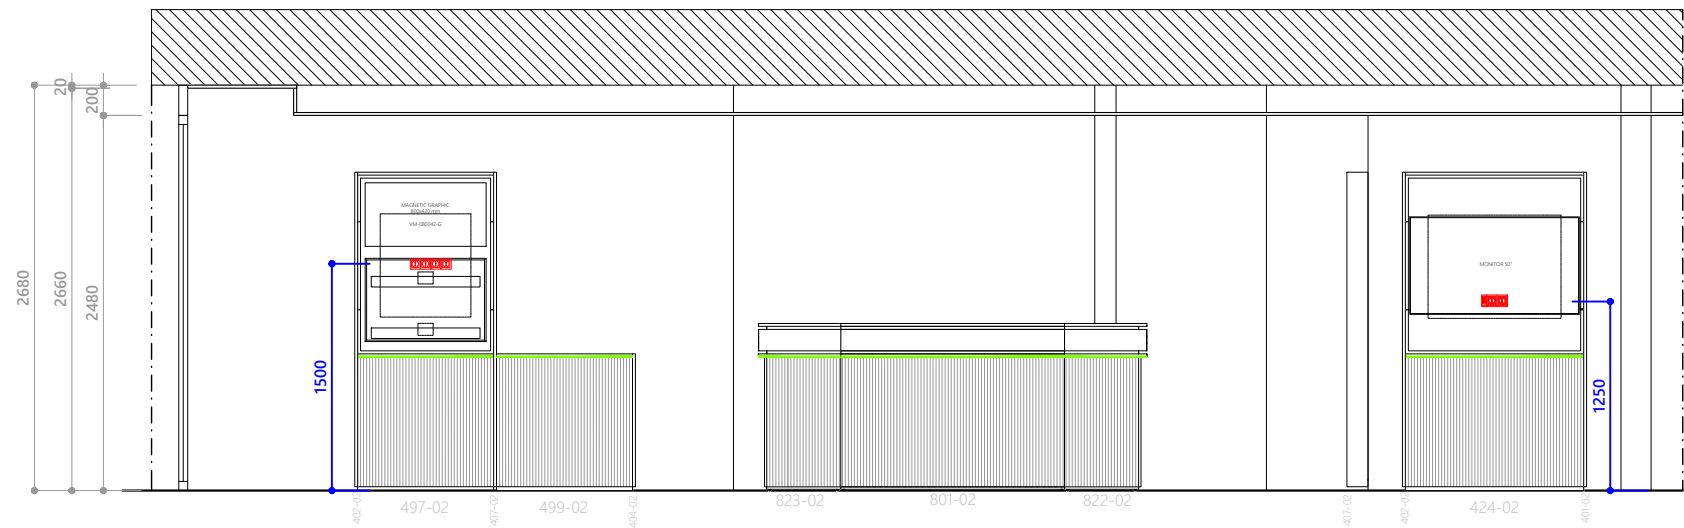


3 ELEVATION FF  
ELEC3 SCALE 1:50 DIMENSION IN MM

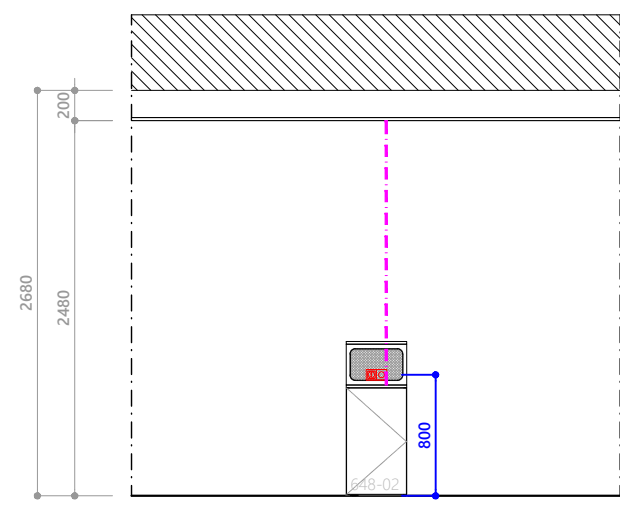


4 ELEVATION GG  
ELEC3 SCALE 1:50 DIMENSION IN MM

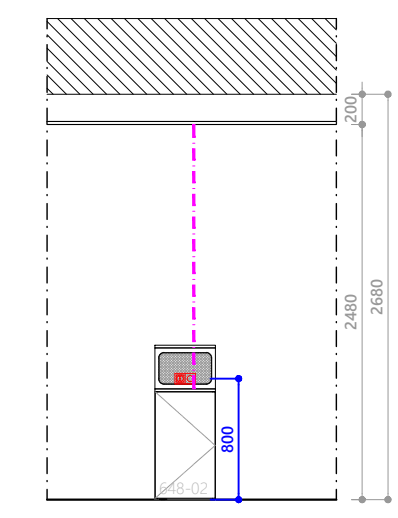

5 ELEVATION HH  
ELEC3 SCALE 1:50 DIMENSION IN MM

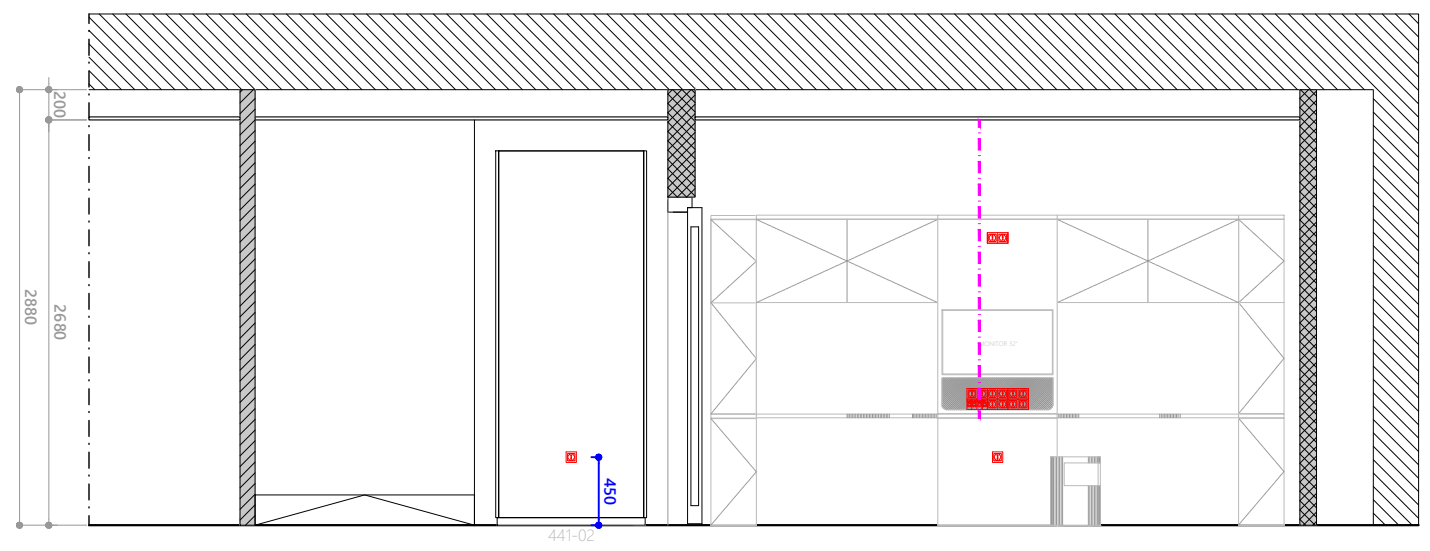

6 ELEVATION II  
ELEC3 SCALE 1:50 DIMENSION IN MM

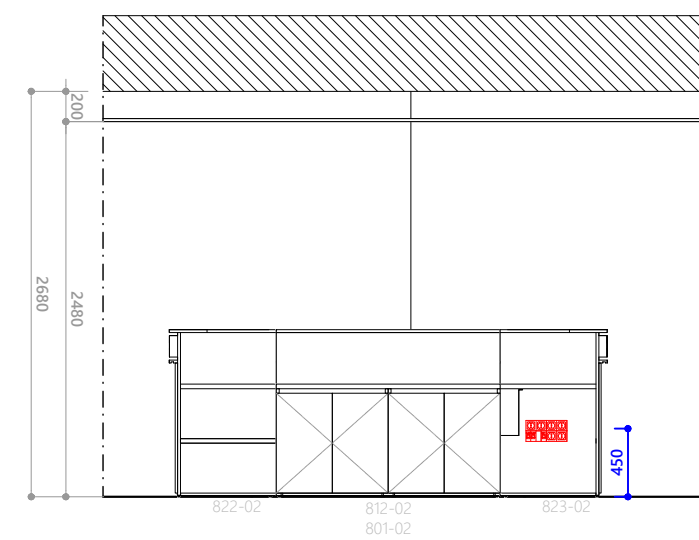

7 ELEVATION LL  
ELEC3 SCALE 1:50 DIMENSION IN MM

**amplifon**  
PROJECT LOCATION:  
**SCHILDE**  
Turnhoutsebaan 91, 2970 Schilde, Belgium  
PROJECT ID NO.:  
**00714-S05366**  
STORE NO.:

**ampli-care**  
**START**

REVISION NO.:  
**REV 05**

STATUS:  
**DDSET**

REVISION LOG:

REV	DATE	DESIGNER
04	07/07/2023	CP
05	21/08/2023	EC

Cleared By: \_\_\_\_\_ Date: \_\_\_\_\_

Store category:  STORE  
 MINI SHOP  
 SIS  
 CORNER

Scope:  NEW  
 REFURBISHMENT  
 RELOCATION  
 LIGHT REFURBISHMENT  
 EXPANSION

TITLE: **ELECTRICAL ELEVATIONS**

SHEET:  
**ELEC3**

THE FOLLOWING DRAWINGS ARE FOR DESIGN INTENT ONLY  
AND ARE NOT TO BE USED FOR CONSTRUCTION.



**amplifon**

PROJECT LOCATION:

**SCHILDE**

Turnhoutsebaan 91, 2970 Schilde, Belgium

STORE NO.:

**00714-S05366**

**ampli-care**

**START**

REVISION NO.:

**REV 05**

STATUS:

**DDSET**

REVISION LOG:

REV	DATE	DESIGNER
04	07/07/2023	CP
05	21/08/2023	EC

Cleared By: \_\_\_\_\_ Date: \_\_\_\_\_

Store category:  STORE  
 MINI SHOP  
 SIS  
 CORNER

Scope:  NEW  
 REFURBISHMENT  
 RELOCATION  
 LIGHT REFURBISHMENT  
 EXPANSION

TITLE:

**RENDERING**

SHEET:

**R01**

THE FOLLOWING DRAWINGS ARE FOR DESIGN INTENT ONLY  
AND ARE NOT TO BE USED FOR CONSTRUCTION.



**amplifon**

PROJECT LOCATION:

**SCHILDE**

Turnhoutsebaan 91, 2970 Schilde, Belgium

STORE NO.:

**00714-S05366**

**ampli-care**

**START**

REVISION NO.:

**REV 05**

STATUS:

**DDSET**

REVISION LOG:

REV	DATE	DESIGNER
04	07/07/2023	CP
05	21/08/2023	EC

Cleared By: \_\_\_\_\_ Date: \_\_\_\_\_

Store category:  STORE  
 MINI SHOP  
 SIS  
 CORNER

Scope:  NEW  
 REFURBISHMENT  
 RELOCATION  
 LIGHT REFURBISHMENT  
 EXPANSION

TITLE:

**RENDERING**

SHEET:

**R02**

THE FOLLOWING DRAWINGS ARE FOR DESIGN INTENT ONLY  
AND ARE NOT TO BE USED FOR CONSTRUCTION.



**amplifon**

PROJECT LOCATION:  
**SCHILDE**  
Turnhoutsebaan 91, 2970 Schilde, Belgium

STORE NO.:  
**00714-S05366**

**ampli-cake**

**START**

REVISION NO.:

**REV 05**

STATUS:

**DDSET**

REVISION LOG:

REV	DATE	DESIGNER
04	07/07/2023	CP
05	21/08/2023	EC

Cleared By: \_\_\_\_\_ Date: \_\_\_\_\_

Store category:  STORE  
 MINI SHOP  
 SIS  
 CORNER

Scope:  NEW  
 REFURBISHMENT  
 RELOCATION  
 LIGHT REFURBISHMENT  
 EXPANSION

TITLE:

**RENDERING**

SHEET:

**R03**

THE FOLLOWING DRAWINGS ARE FOR DESIGN INTENT ONLY AND ARE NOT TO BE USED FOR CONSTRUCTION.



**amplifon**  
PROJECT LOCATION:  
**SCHILDE**  
Turnhoutsebaan 91, 2970 Schilde, Belgium  
PROJECT ID NO.:  
**00714-S05366**  
STORE NO.:

**ampli-care**

**START**

REVISION NO.:

**REV 05**

STATUS:

**DDSET**

REVISION LOG:

REV	DATE	DESIGNER
04	07/07/2023	CP
05	21/08/2023	EC

Cleared By: \_\_\_\_\_ Date: \_\_\_\_\_

Store category:  STORE  
 MINI SHOP  
 SIS  
 CORNER

Scope:  NEW  
 REFURBISHMENT  
 RELOCATION  
 LIGHT REFURBISHMENT  
 EXPANSION

TITLE:

**RENDERING**

SHEET:

**R04**

THE FOLLOWING DRAWINGS ARE FOR DESIGN INTENT ONLY  
AND ARE NOT TO BE USED FOR CONSTRUCTION.



**amplifon**

PROJECT LOCATION:

**SCHILDE**

Turnhoutsebaan 91, 2970 Schilde, Belgium

STORE NO.:

00714-S05366

**ampli-cake**

**START**

REVISION NO.:

**REV 05**

STATUS:

**DDSET**

REVISION LOG:

REV	DATE	DESIGNER
04	07/07/2023	CP
05	21/08/2023	EC

Cleared By: \_\_\_\_\_ Date: \_\_\_\_\_

Store category:  STORE  
 MINI SHOP  
 SIS  
 CORNER

Scope:  NEW  
 REFURBISHMENT  
 RELOCATION  
 LIGHT REFURBISHMENT  
 EXPANSION

TITLE:

**RENDERING**

SHEET:

**R05**